
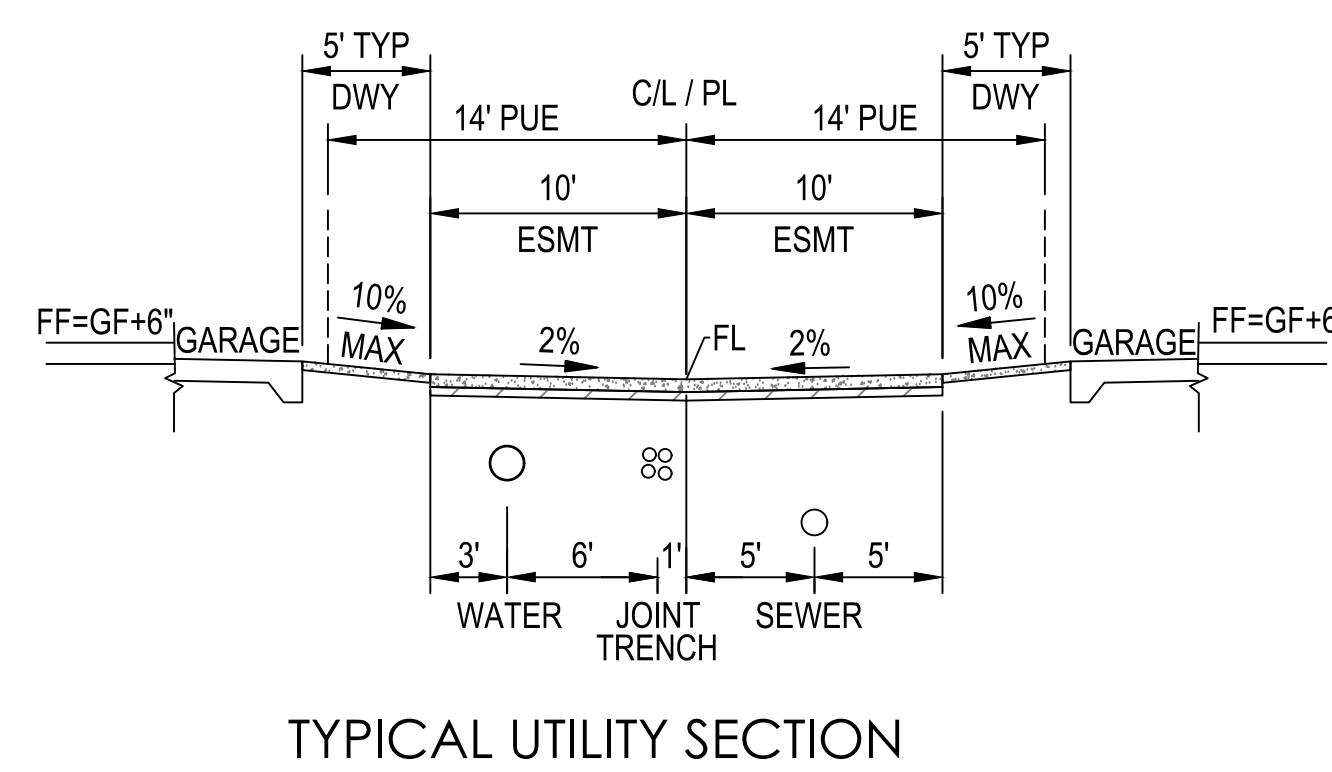


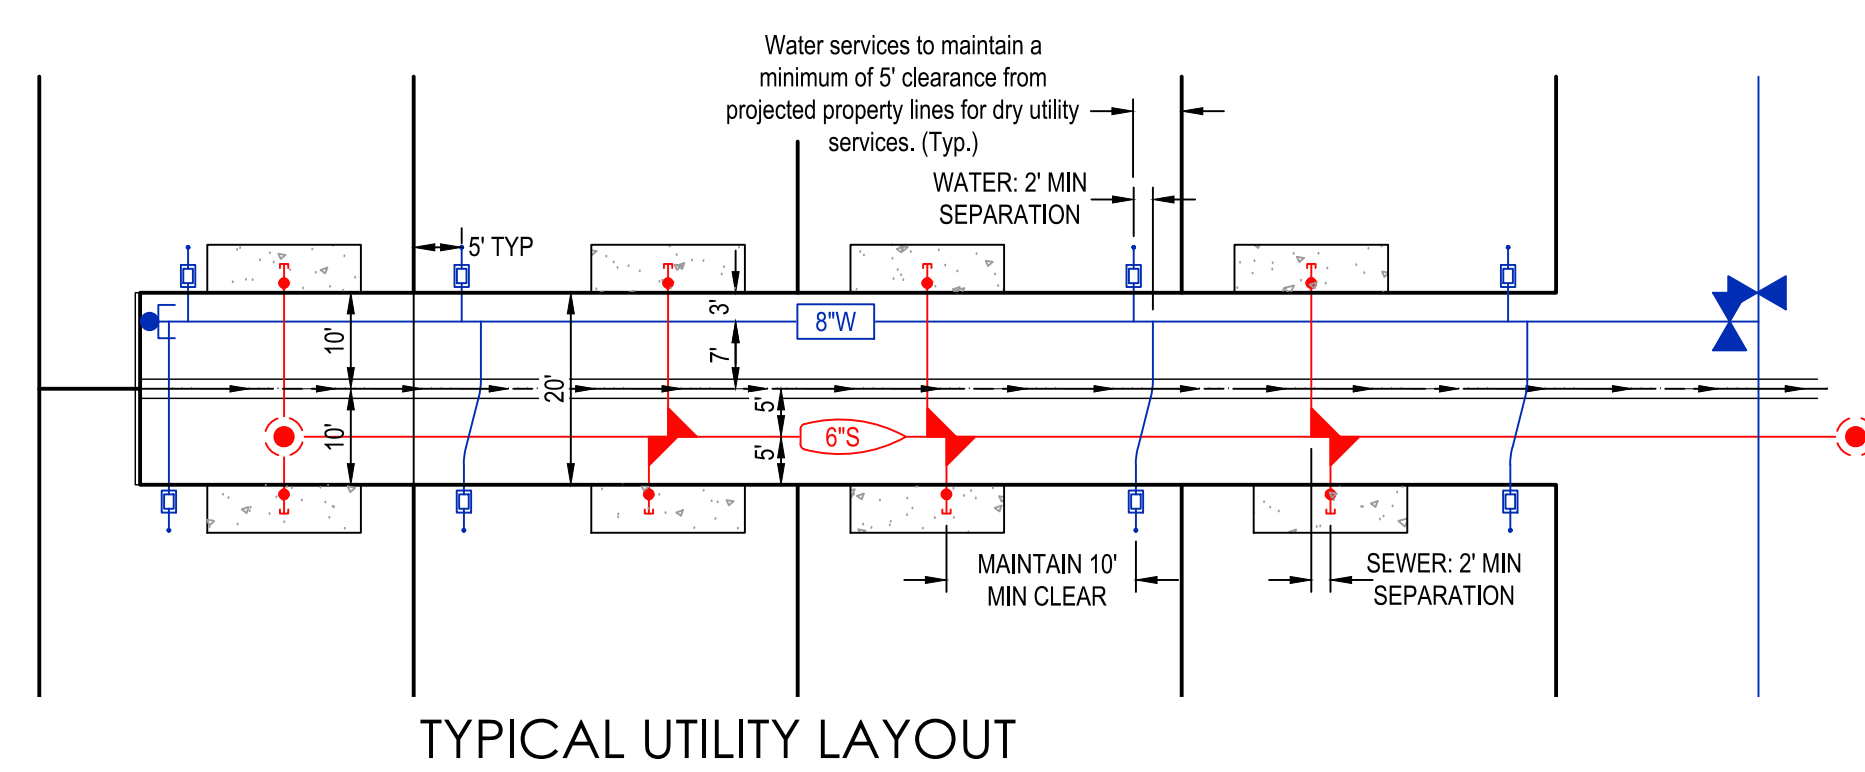

EXISTING	PROPOSED	DESCRIPTION
		SANITARY SEWER PIPE & SIZE
		DOMESTIC WATER PIPE & SIZE
		SANITARY SEWER MANHOLE
		GATE VALVE
		FIRE HYDRANT
		BLOW OFF VALVE
		AIR RELIEF VALVE
		WATER SERVICE
		SEWER SERVICE

SYMBOLS



PC Exhibit G

PRELIMINARY UTILITY PLAN

WATER SERVICE LOCATION VARIANCE REQUESTS

LOTS:

• 1	• 9	• 22
• 4	• 13	• 26
• 5	• 15	• 27
• 6	• 16	• 34
• 7	• 17	• 57
• 8	• 20	

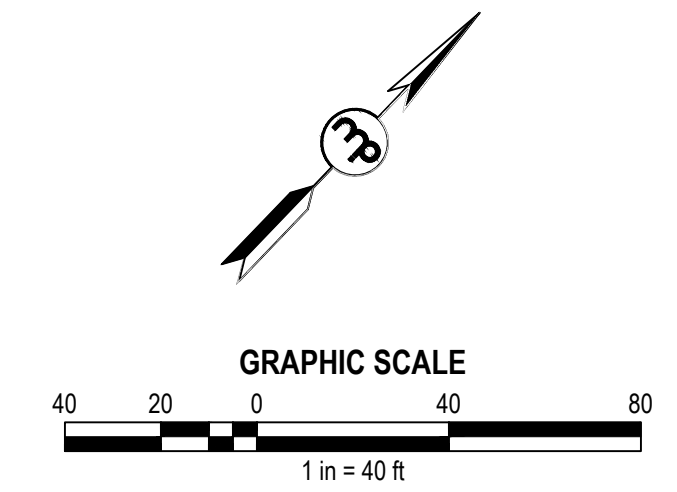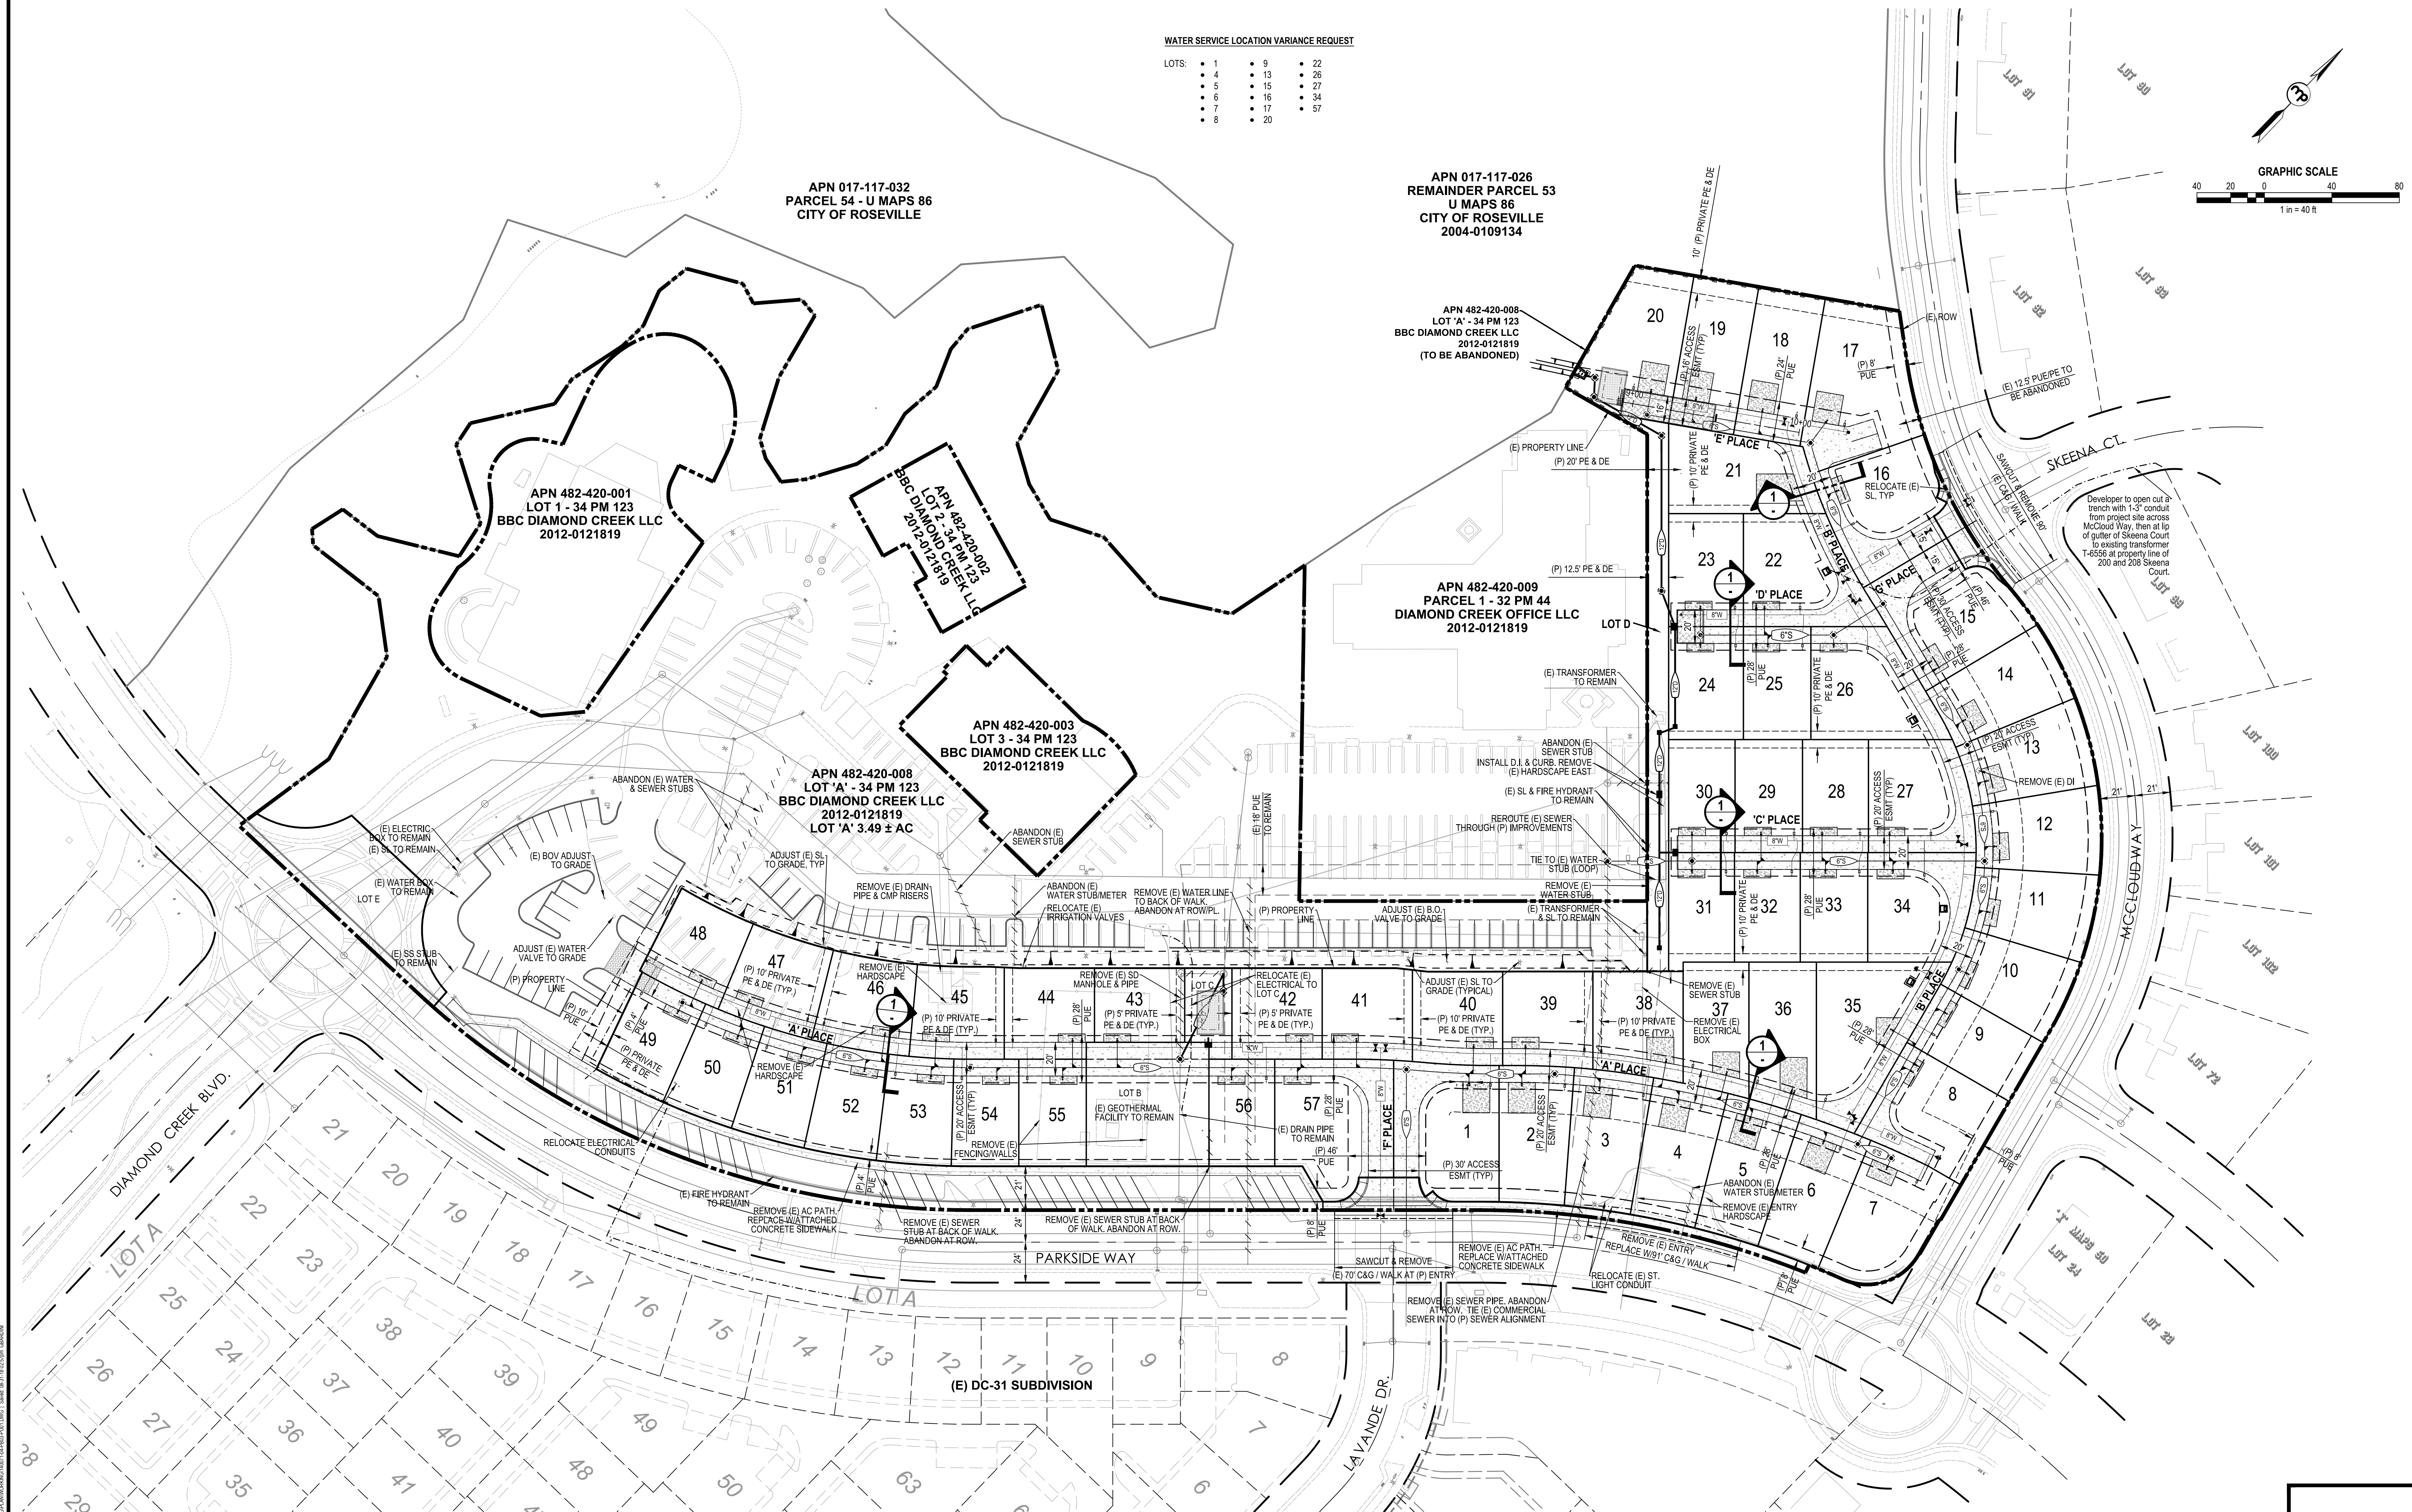[illegible]

COMPUTED BY	MC
DESIGNED BY	KT
DRAWN BY	SP/TA
PROJECT ENGINEER	GJB

DIAMOND CREEK
DC 30 & 33

ROSEVILLE, CA

PRELIMINARY UTILITY PLAN

DATE	AUGUST 31, 2018	SHEET	4
SCALE	1" = 40'		
JOB NUMBER	14-0071-01	OF	4