


3/29/2022 11:27:49 AM C:\Users\mwalsh\Documents\Local Files\C1009.00-Sutter Parking Garage 2 Expansion_A21_mwalsh\0329\2.rvt

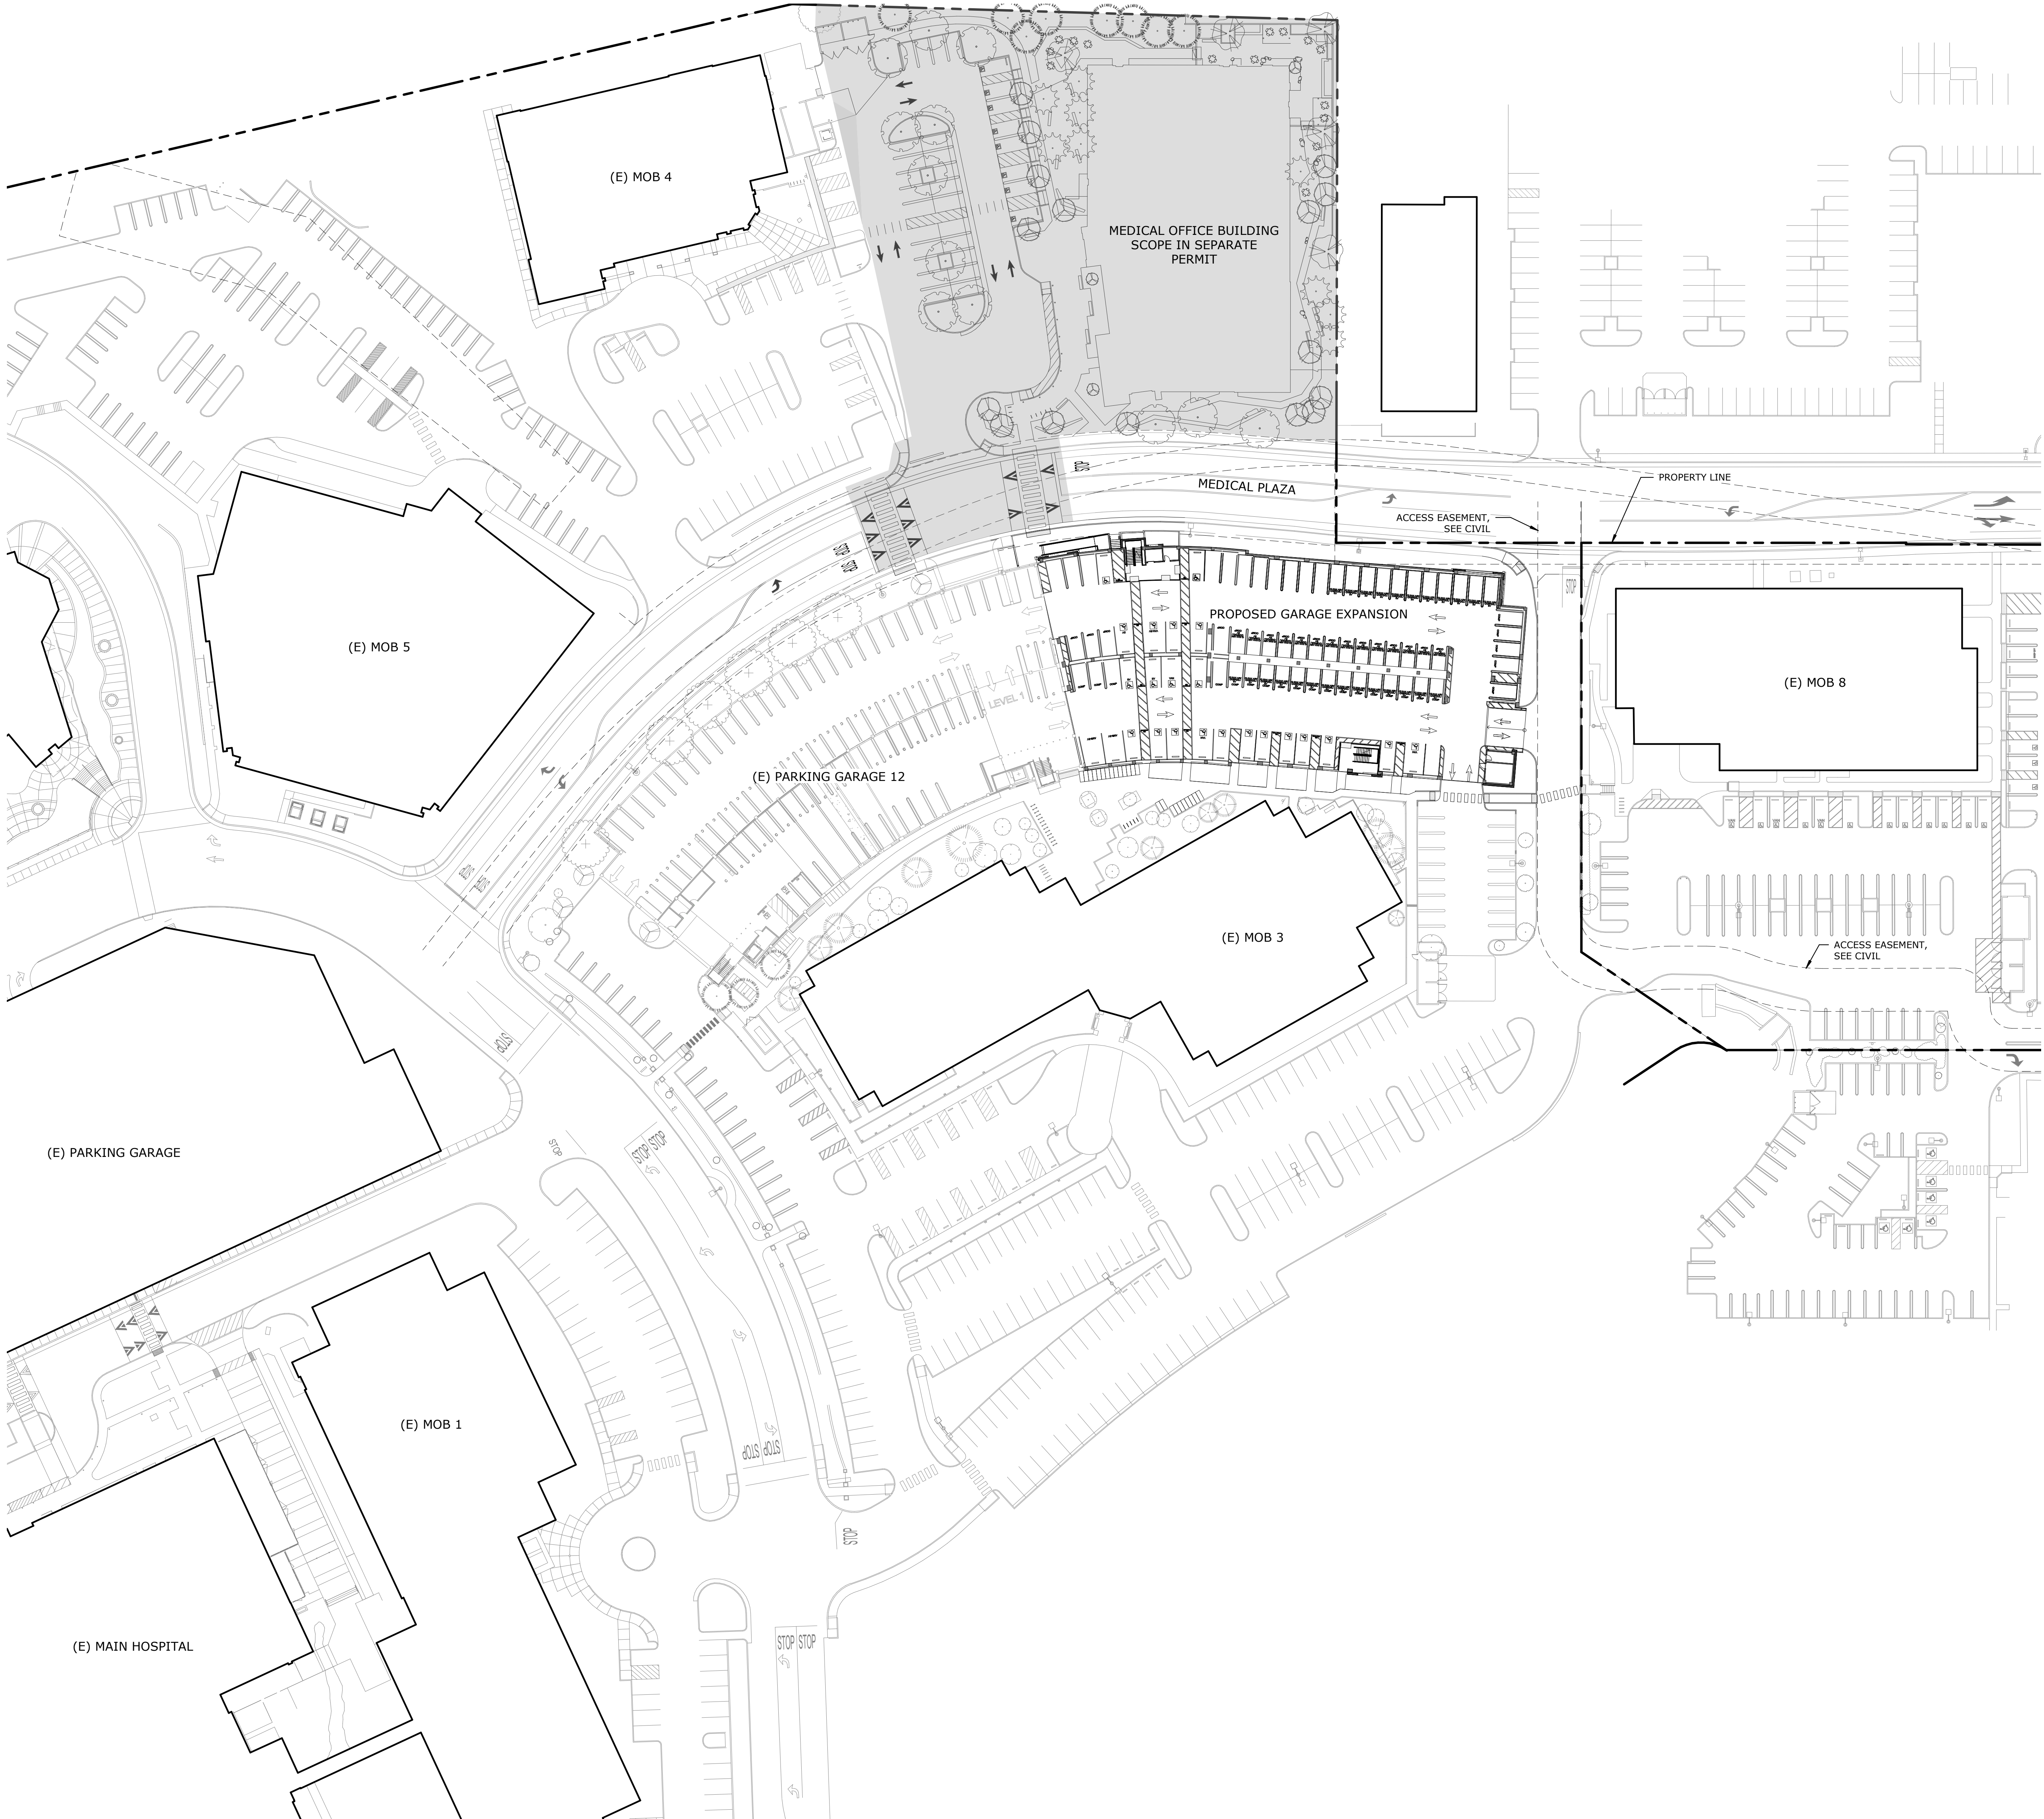

GENERAL NOTES

1. THE ACCESSIBLE ROUTE OF TRAVEL (OR PATH OF TRAVEL) IS A CONTINUOUS UNOBSTRUCTED WALKWAY (OR PATH) CONNECTING ALL ACCESSIBLE ELEMENTS AND SPACES AS INDICATED ON THIS SHEET. THE CONTRACTOR SHALL VERIFY THAT A PERSON CAN NEGOTIATE THE ACCESSIBLE ROUTE WITH A DISABILITY USING A WHEELCHAIR AND THAT THE ROUTE IS ALSO SAFE AND USABLE BY PERSONS WITH OTHER DISABILITIES.
2. ALL WALKS, SIDEWALKS AND LANDINGS THAT ARE PART OF THE ACCESSIBLE ROUTE OF TRAVEL SHALL HAVE A CONTINUOUS COMMON SURFACE, NOT INTERRUPTED BY STEPS OR BY ABRUPT CHANGES IN LEVEL EXCEEDING 1/2 INCH, AND SHALL HAVE A MINIMUM WIDTH OF 48 INCHES, UNLESS NOTED OTHERWISE. THE SLOPE IN THE DIRECTION OF TRAVEL SHALL BE LESS THAN 1:20 (5%) WITH A MAXIMUM CROSS SLOPE OF 1/4 INCH PER FOOT (2%), UNLESS OTHERWISE NOTED.
3. ALL DESIGNATED ACCESSIBLE RAMPS SHALL HAVE A MAXIMUM SLOPE OF 1:12 (8.33%) IN THE DIRECTION OF TRAVEL WITH A MAXIMUM CROSS SLOPE OF 1/4 INCH PER FOOT (2%), UNLESS OTHERWISE NOTED.
4. SEE CIVIL DRAWINGS FOR FULL EXTENT OF SITE WORK IN THIS CONTRACT.

CITY APPROVAL STAMP



City of Roseville Approval


THIS DRAWING IS NOT FINAL OR TO BE
USED FOR CONSTRUCTION UNTIL IT IS
SIGNED BY THE ARCHITECT/ENGINEER

REVISION BY DATE


SUTTER HEALTH
PARKING GARAGE 12
EXPANSION

12 MEDICAL PLAZA
ROSEVILLE, CA 95661

OVERALL SITE PLAN

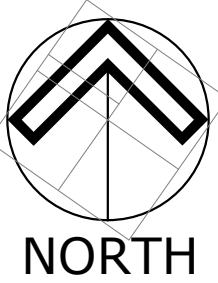

C1009.00
AS SHOWN
03/28/2022

 

City of Roseville Approval


THIS DRAWING IS NOT FINAL OR TO BE
USED FOR CONSTRUCTION UNTIL IT IS
SIGNED BY THE ARCHITECT/ENGINEER

REVISION	BY	DATE
----------	----	------

12 MEDICAL PLAZA
ROSEVILLE, CA 95661




C1009.00
AS SHOWN
03/28/2022

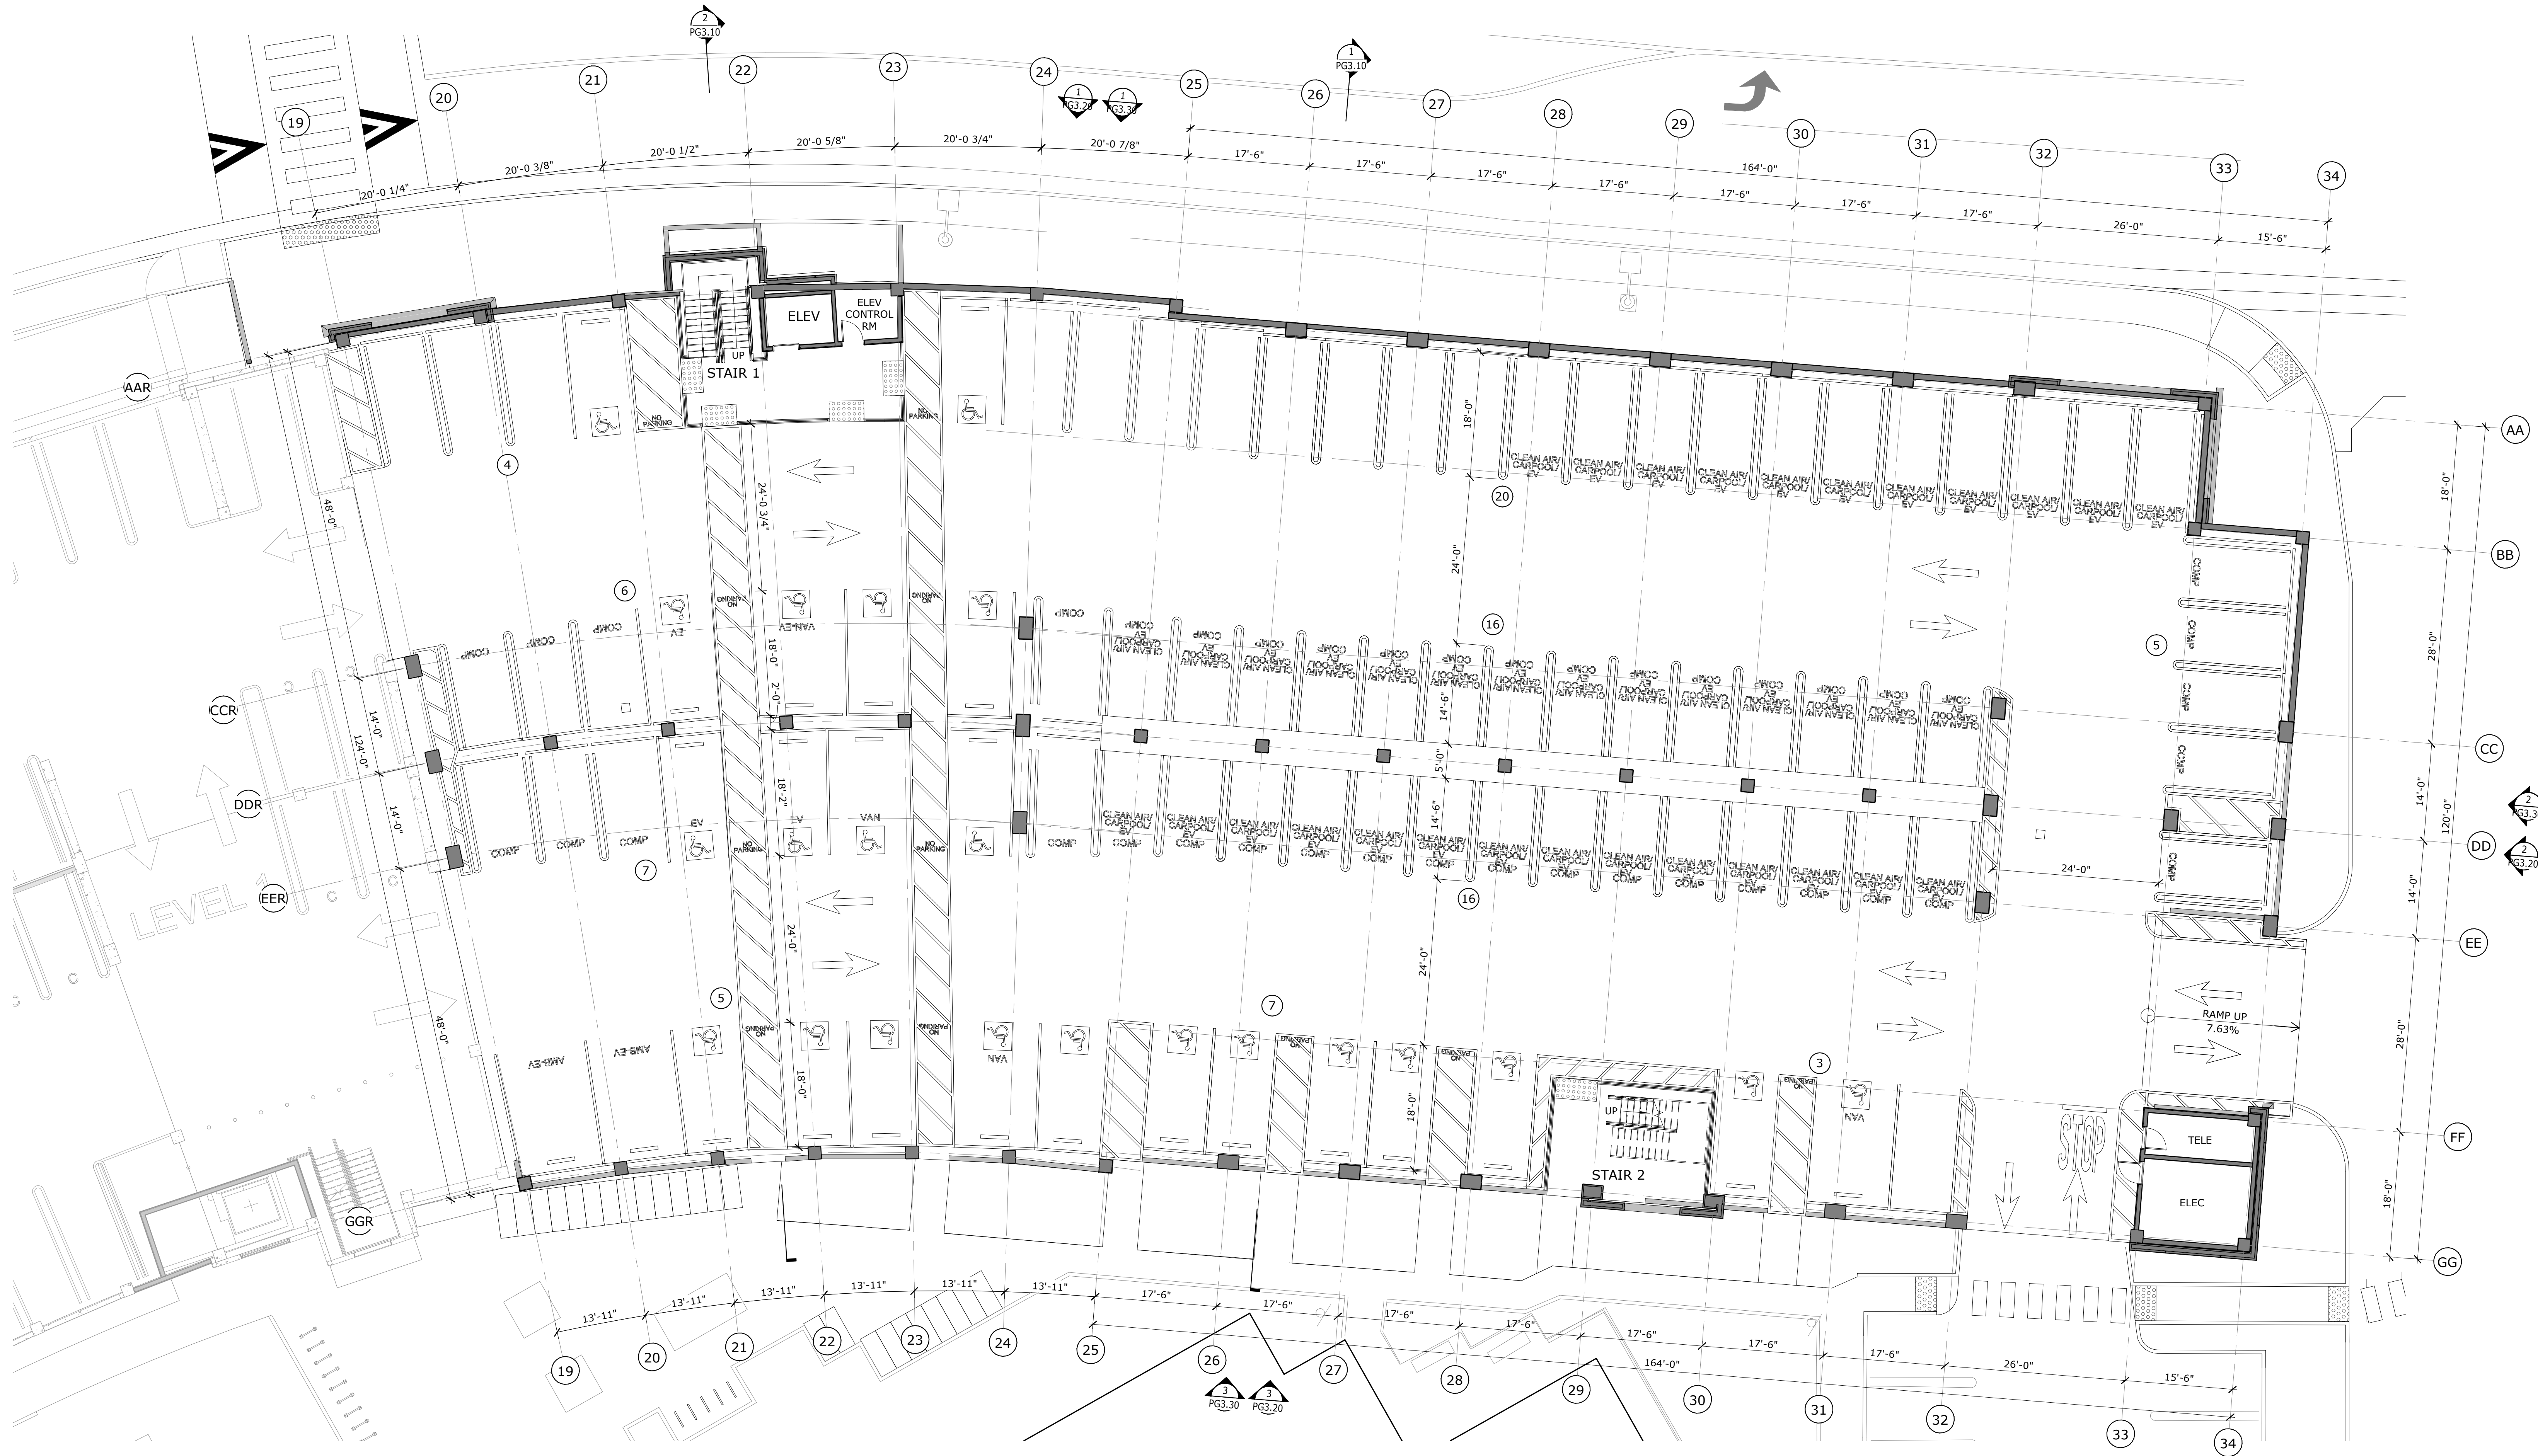

1 LEVEL 01-FLOOR PLAN
3/32" = 1'-0"

CITY APPROVAL STAMP

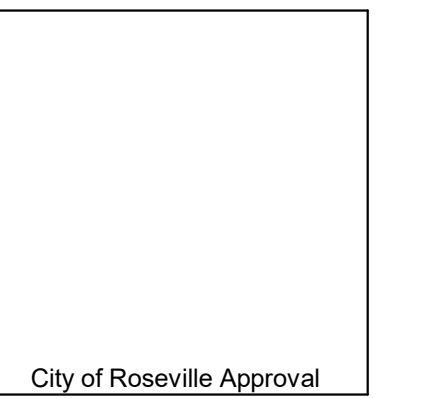

THIS DRAWING IS NOT FINAL OR TO BE
USED FOR CONSTRUCTION UNTIL IT IS
SIGNED BY THE ARCHITECT/ENGINEER

REVISION BY DATE

SUTTER HEALTH
PARKING GARAGE 12
EXPANSION


12 MEDICAL PLAZA
ROSEVILLE, CA 95661

LEVEL 01 FLOOR PLAN




C1009.00
AS SHOWN
03/28/2022

PG2.11

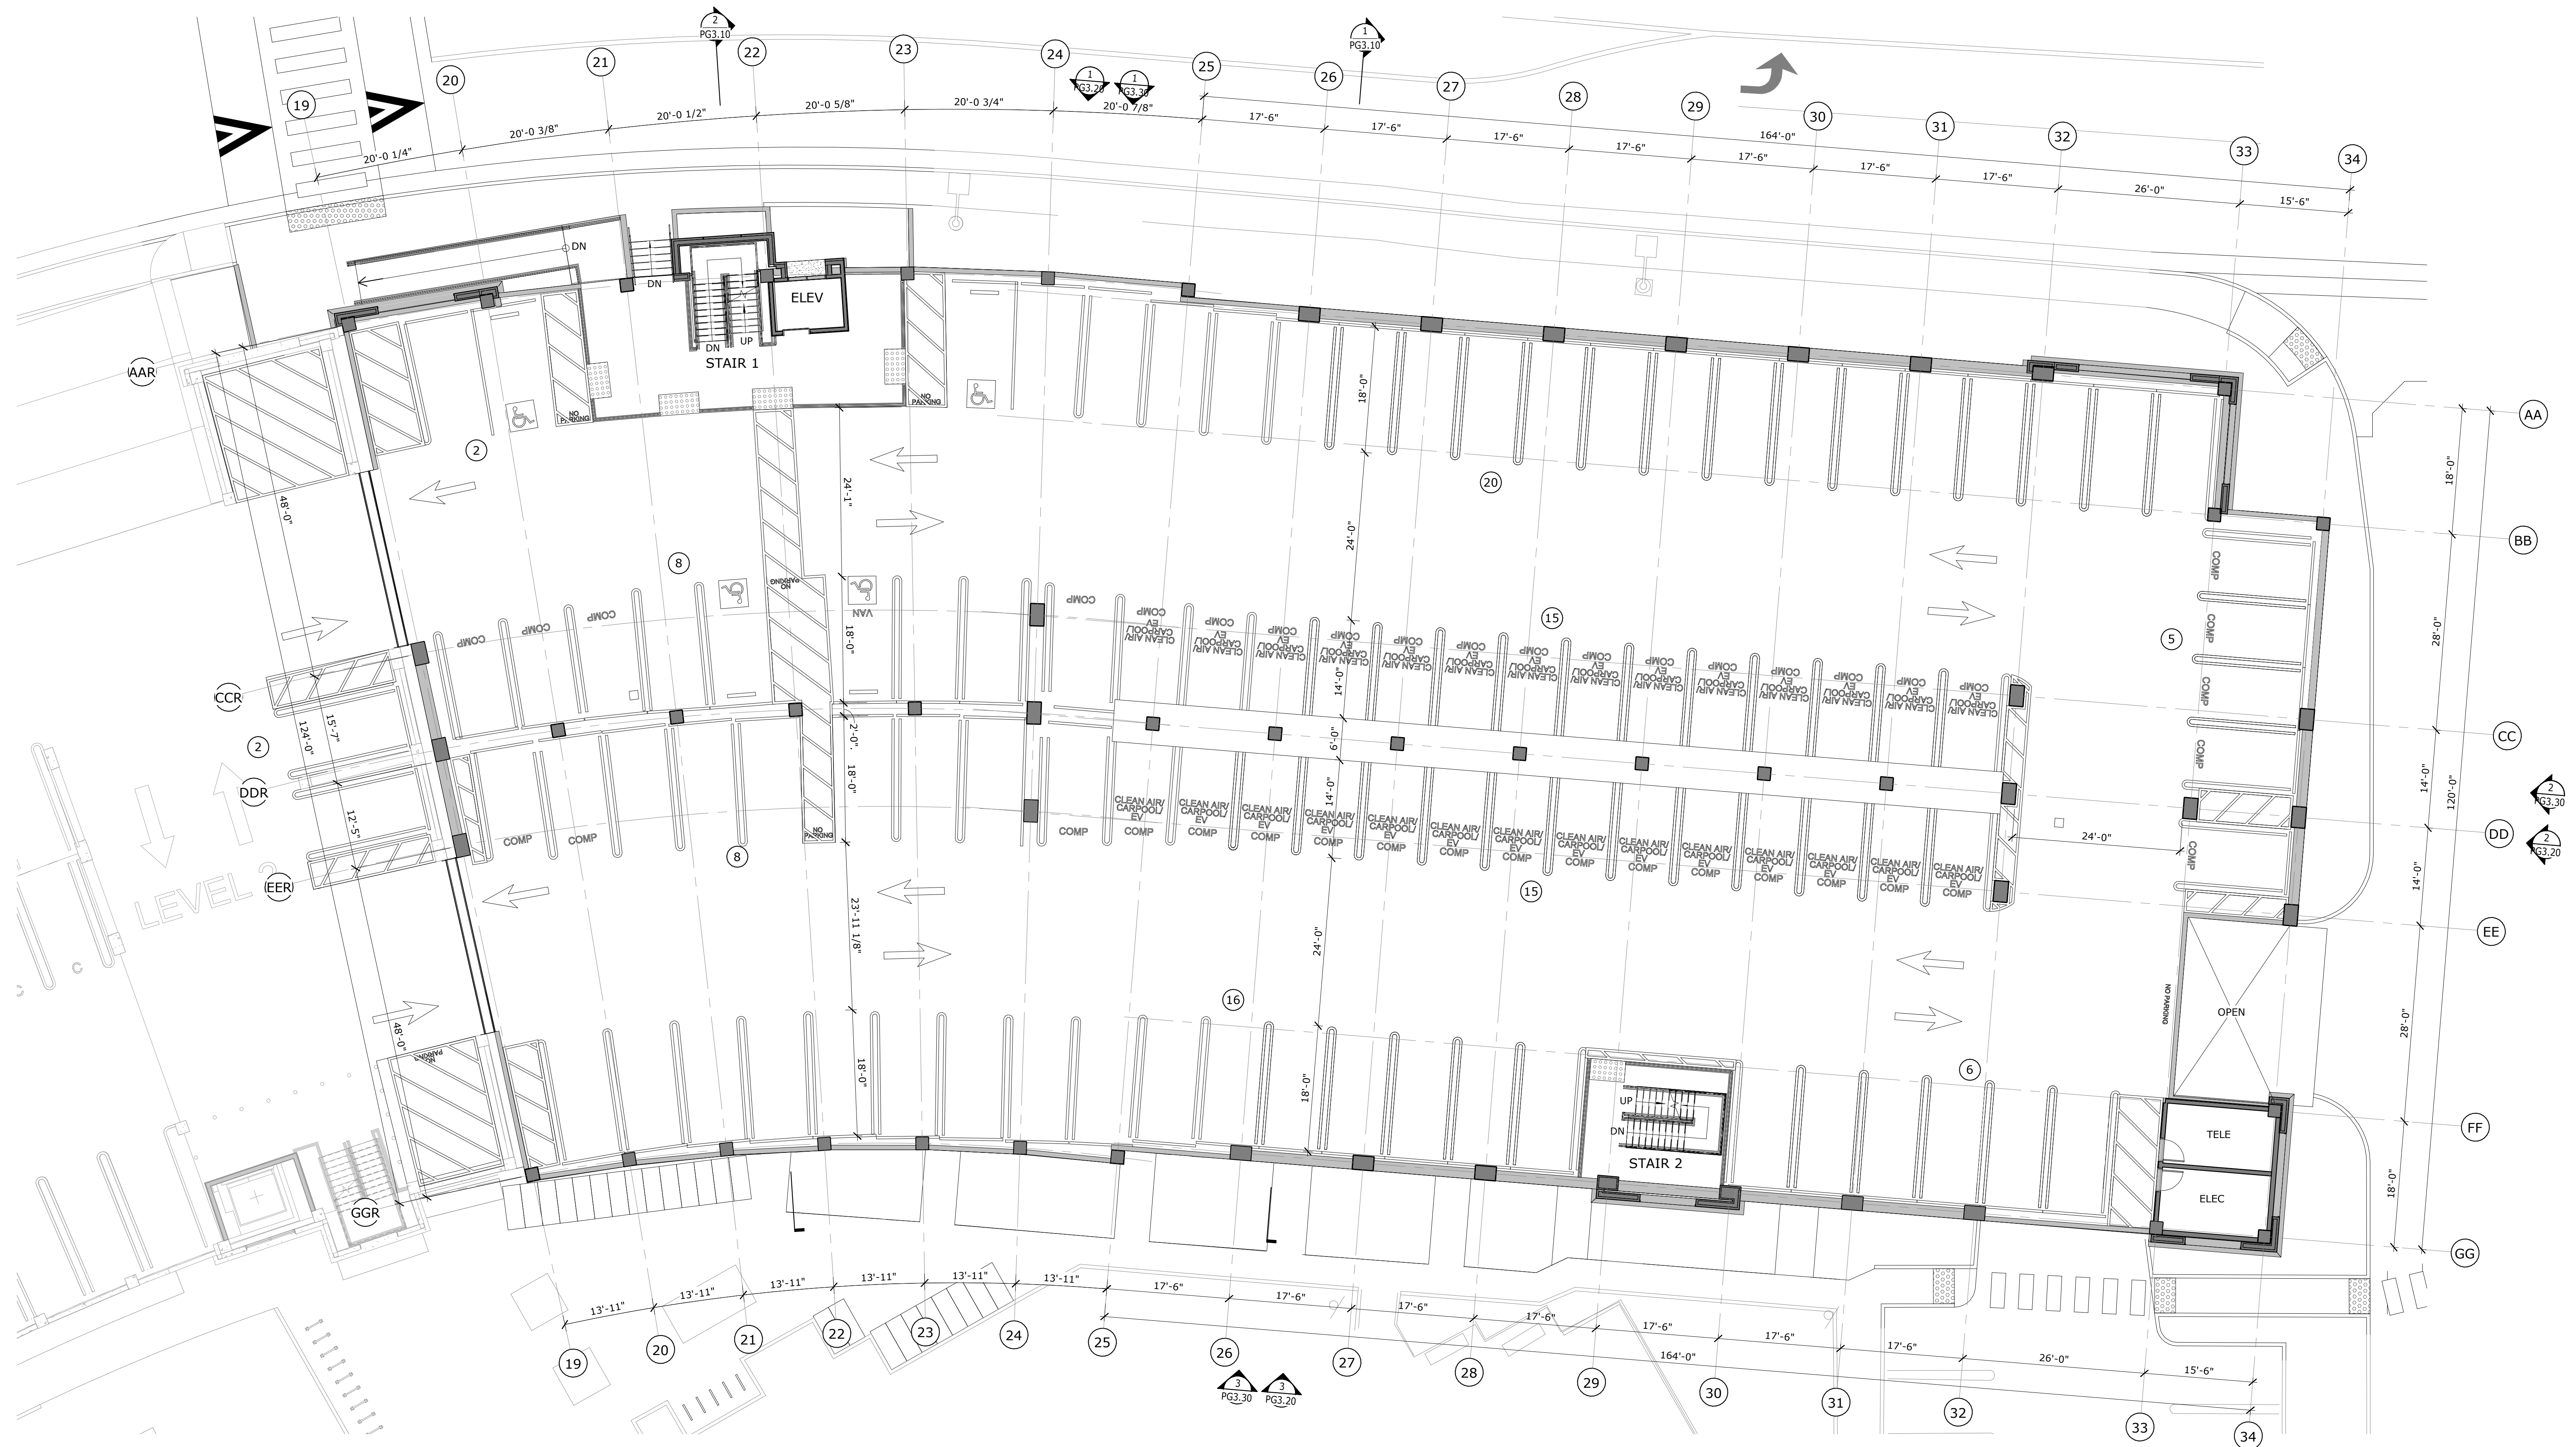

CITY APPROVAL STAMP

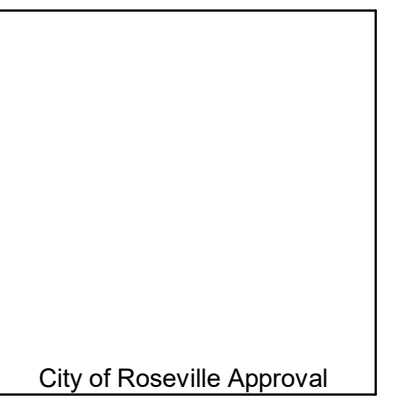

THIS DRAWING IS NOT FINAL OR TO BE
USED FOR CONSTRUCTION UNTIL IT IS
SIGNED BY THE ARCHITECT/ENGINEER

REVISION BY DATE

1 LEVEL 02-FLOOR PLAN
3/32" = 1'-0"

SUTTER HEALTH
PARKING GARAGE 12
EXPANSION


12 MEDICAL PLAZA
ROSEVILLE, CA 95661

LEVEL 02 FLOOR PLAN




C1009.00
AS SHOWN
03/28/2022

PG2.21

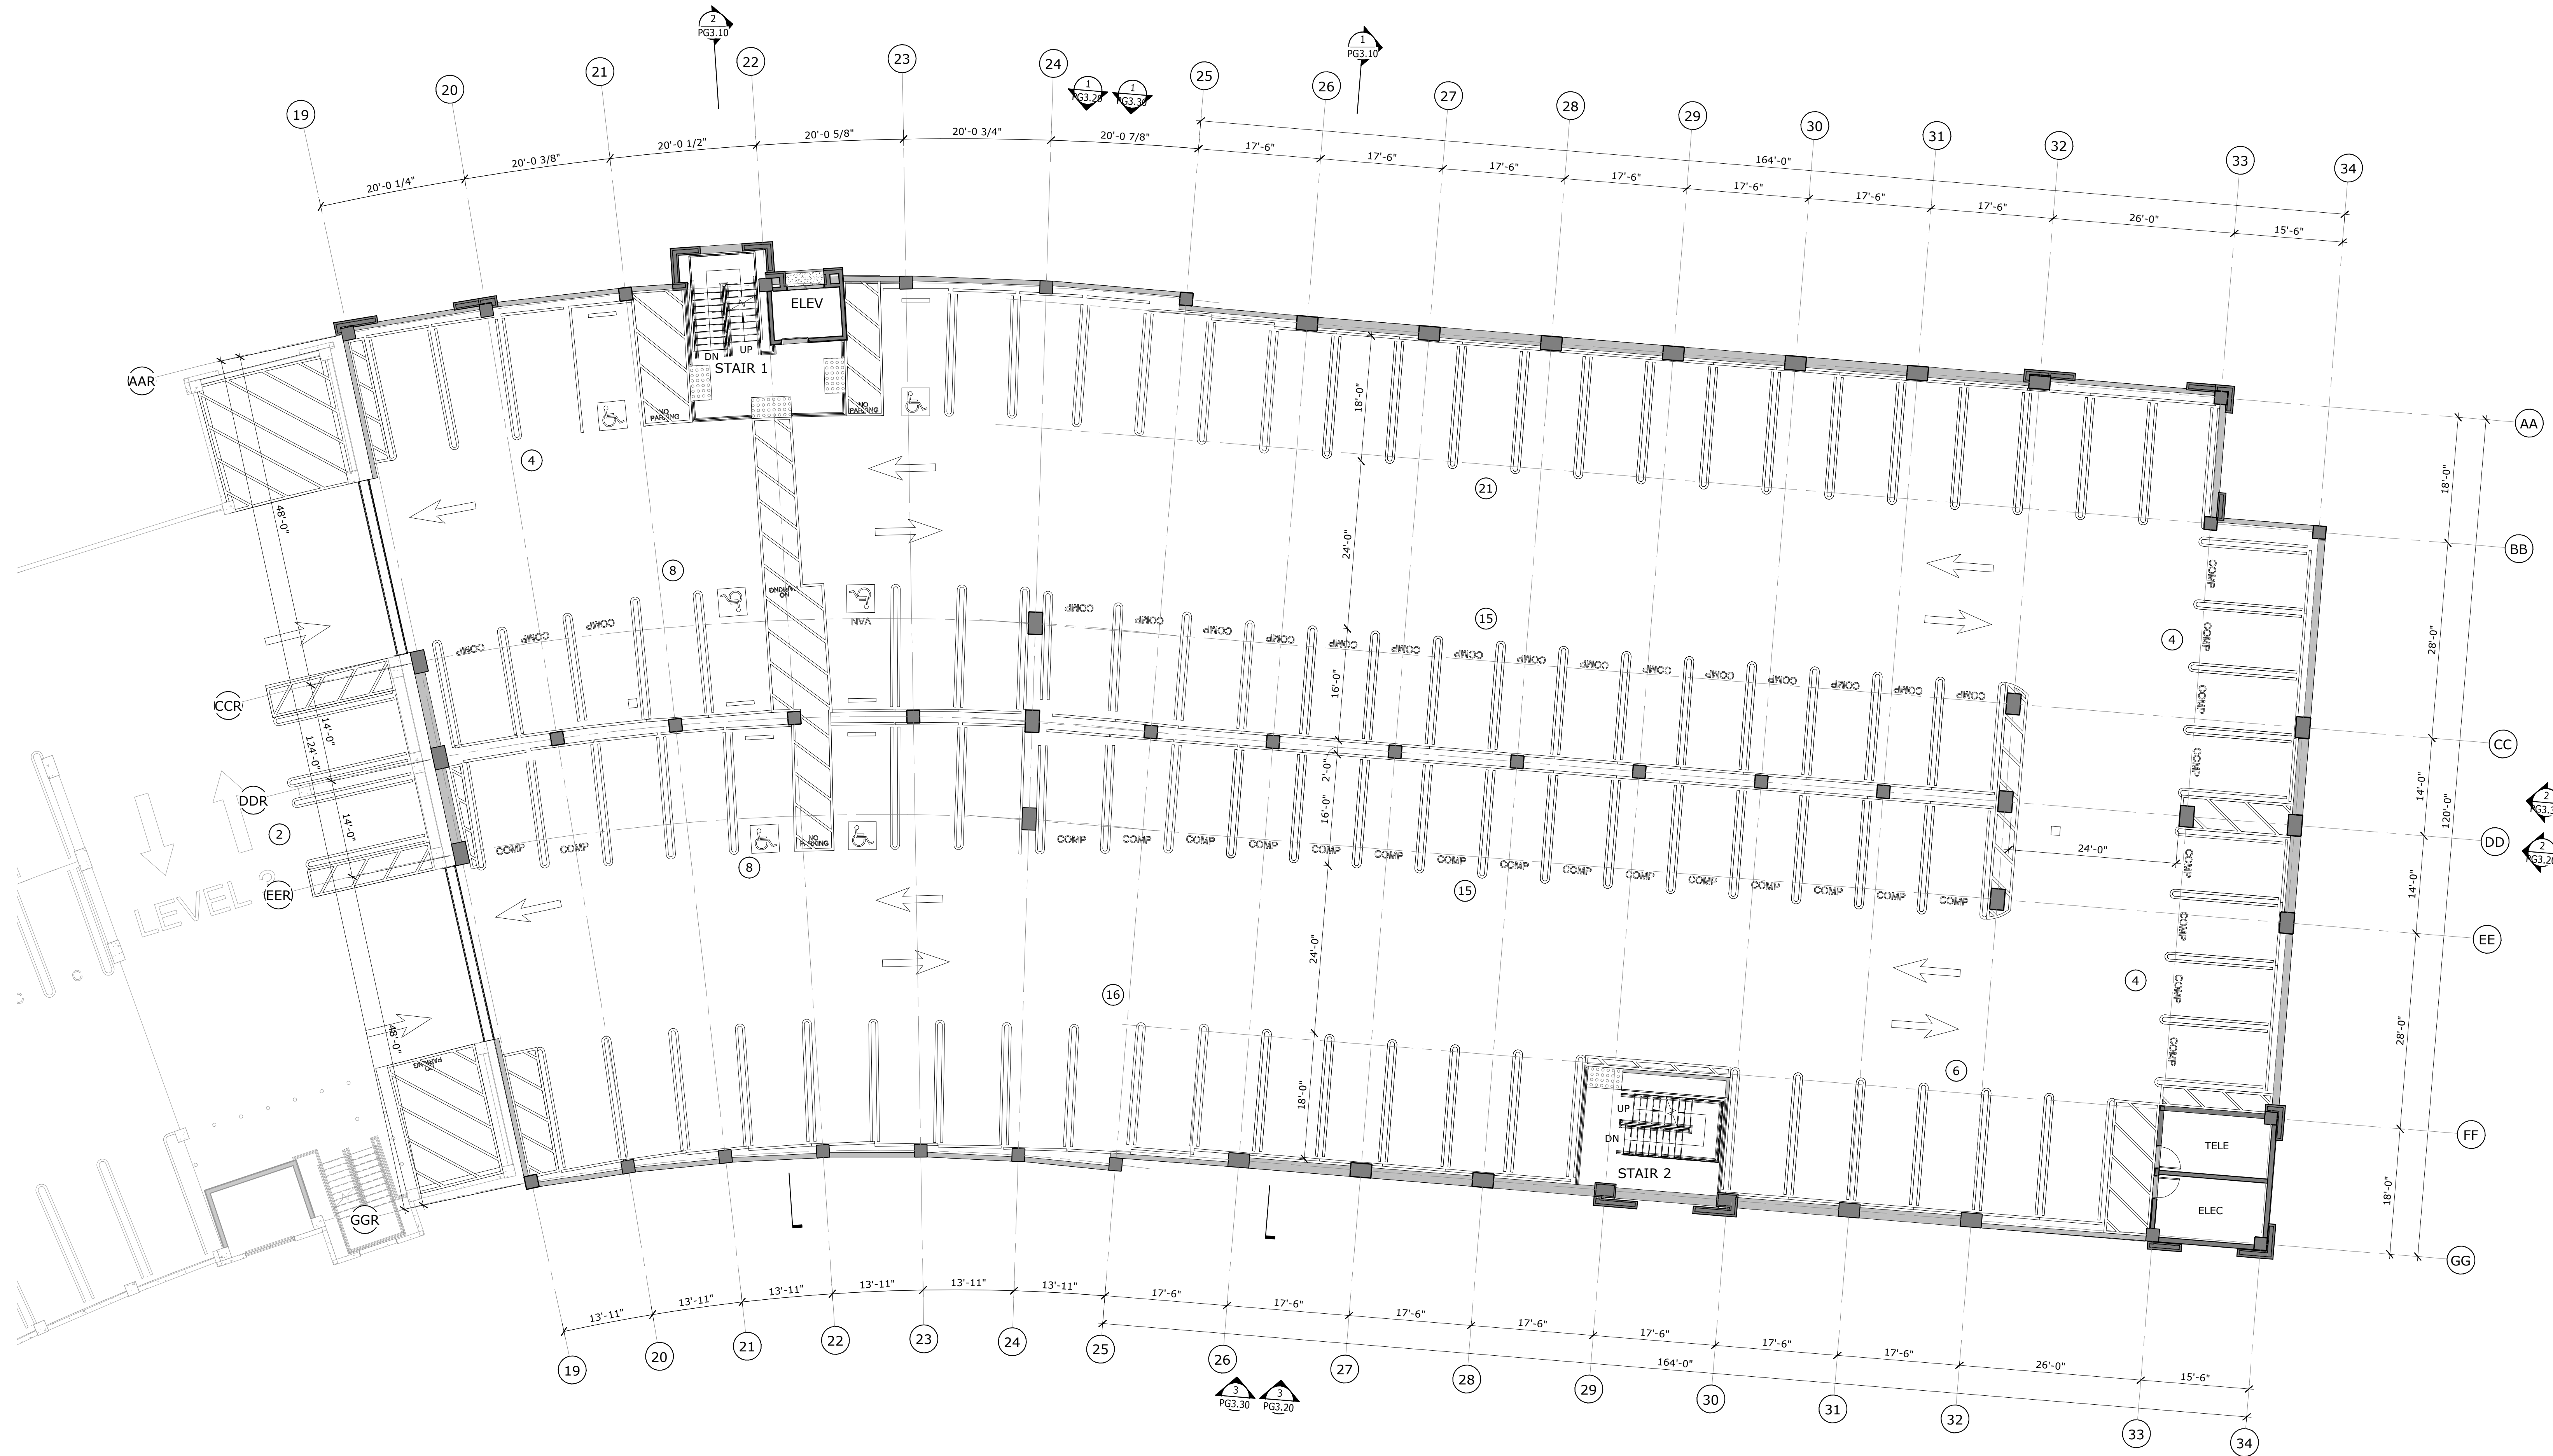

1 LEVEL 03-FLOOR PLAN
3/32" = 1'-0"

CITY APPROVAL STAMP

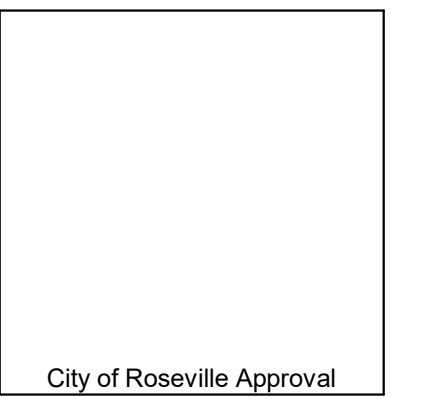

THIS DRAWING IS NOT FINAL OR TO BE
USED FOR CONSTRUCTION UNTIL IT IS
SIGNED BY THE ARCHITECT/ENGINEER

REVISION BY DATE

SUTTER HEALTH
PARKING GARAGE 12
EXPANSION


12 MEDICAL PLAZA
ROSEVILLE, CA 95661


LEVEL 03 FLOOR PLAN




C1009.00
AS SHOWN
03/28/2022

 PG2.31



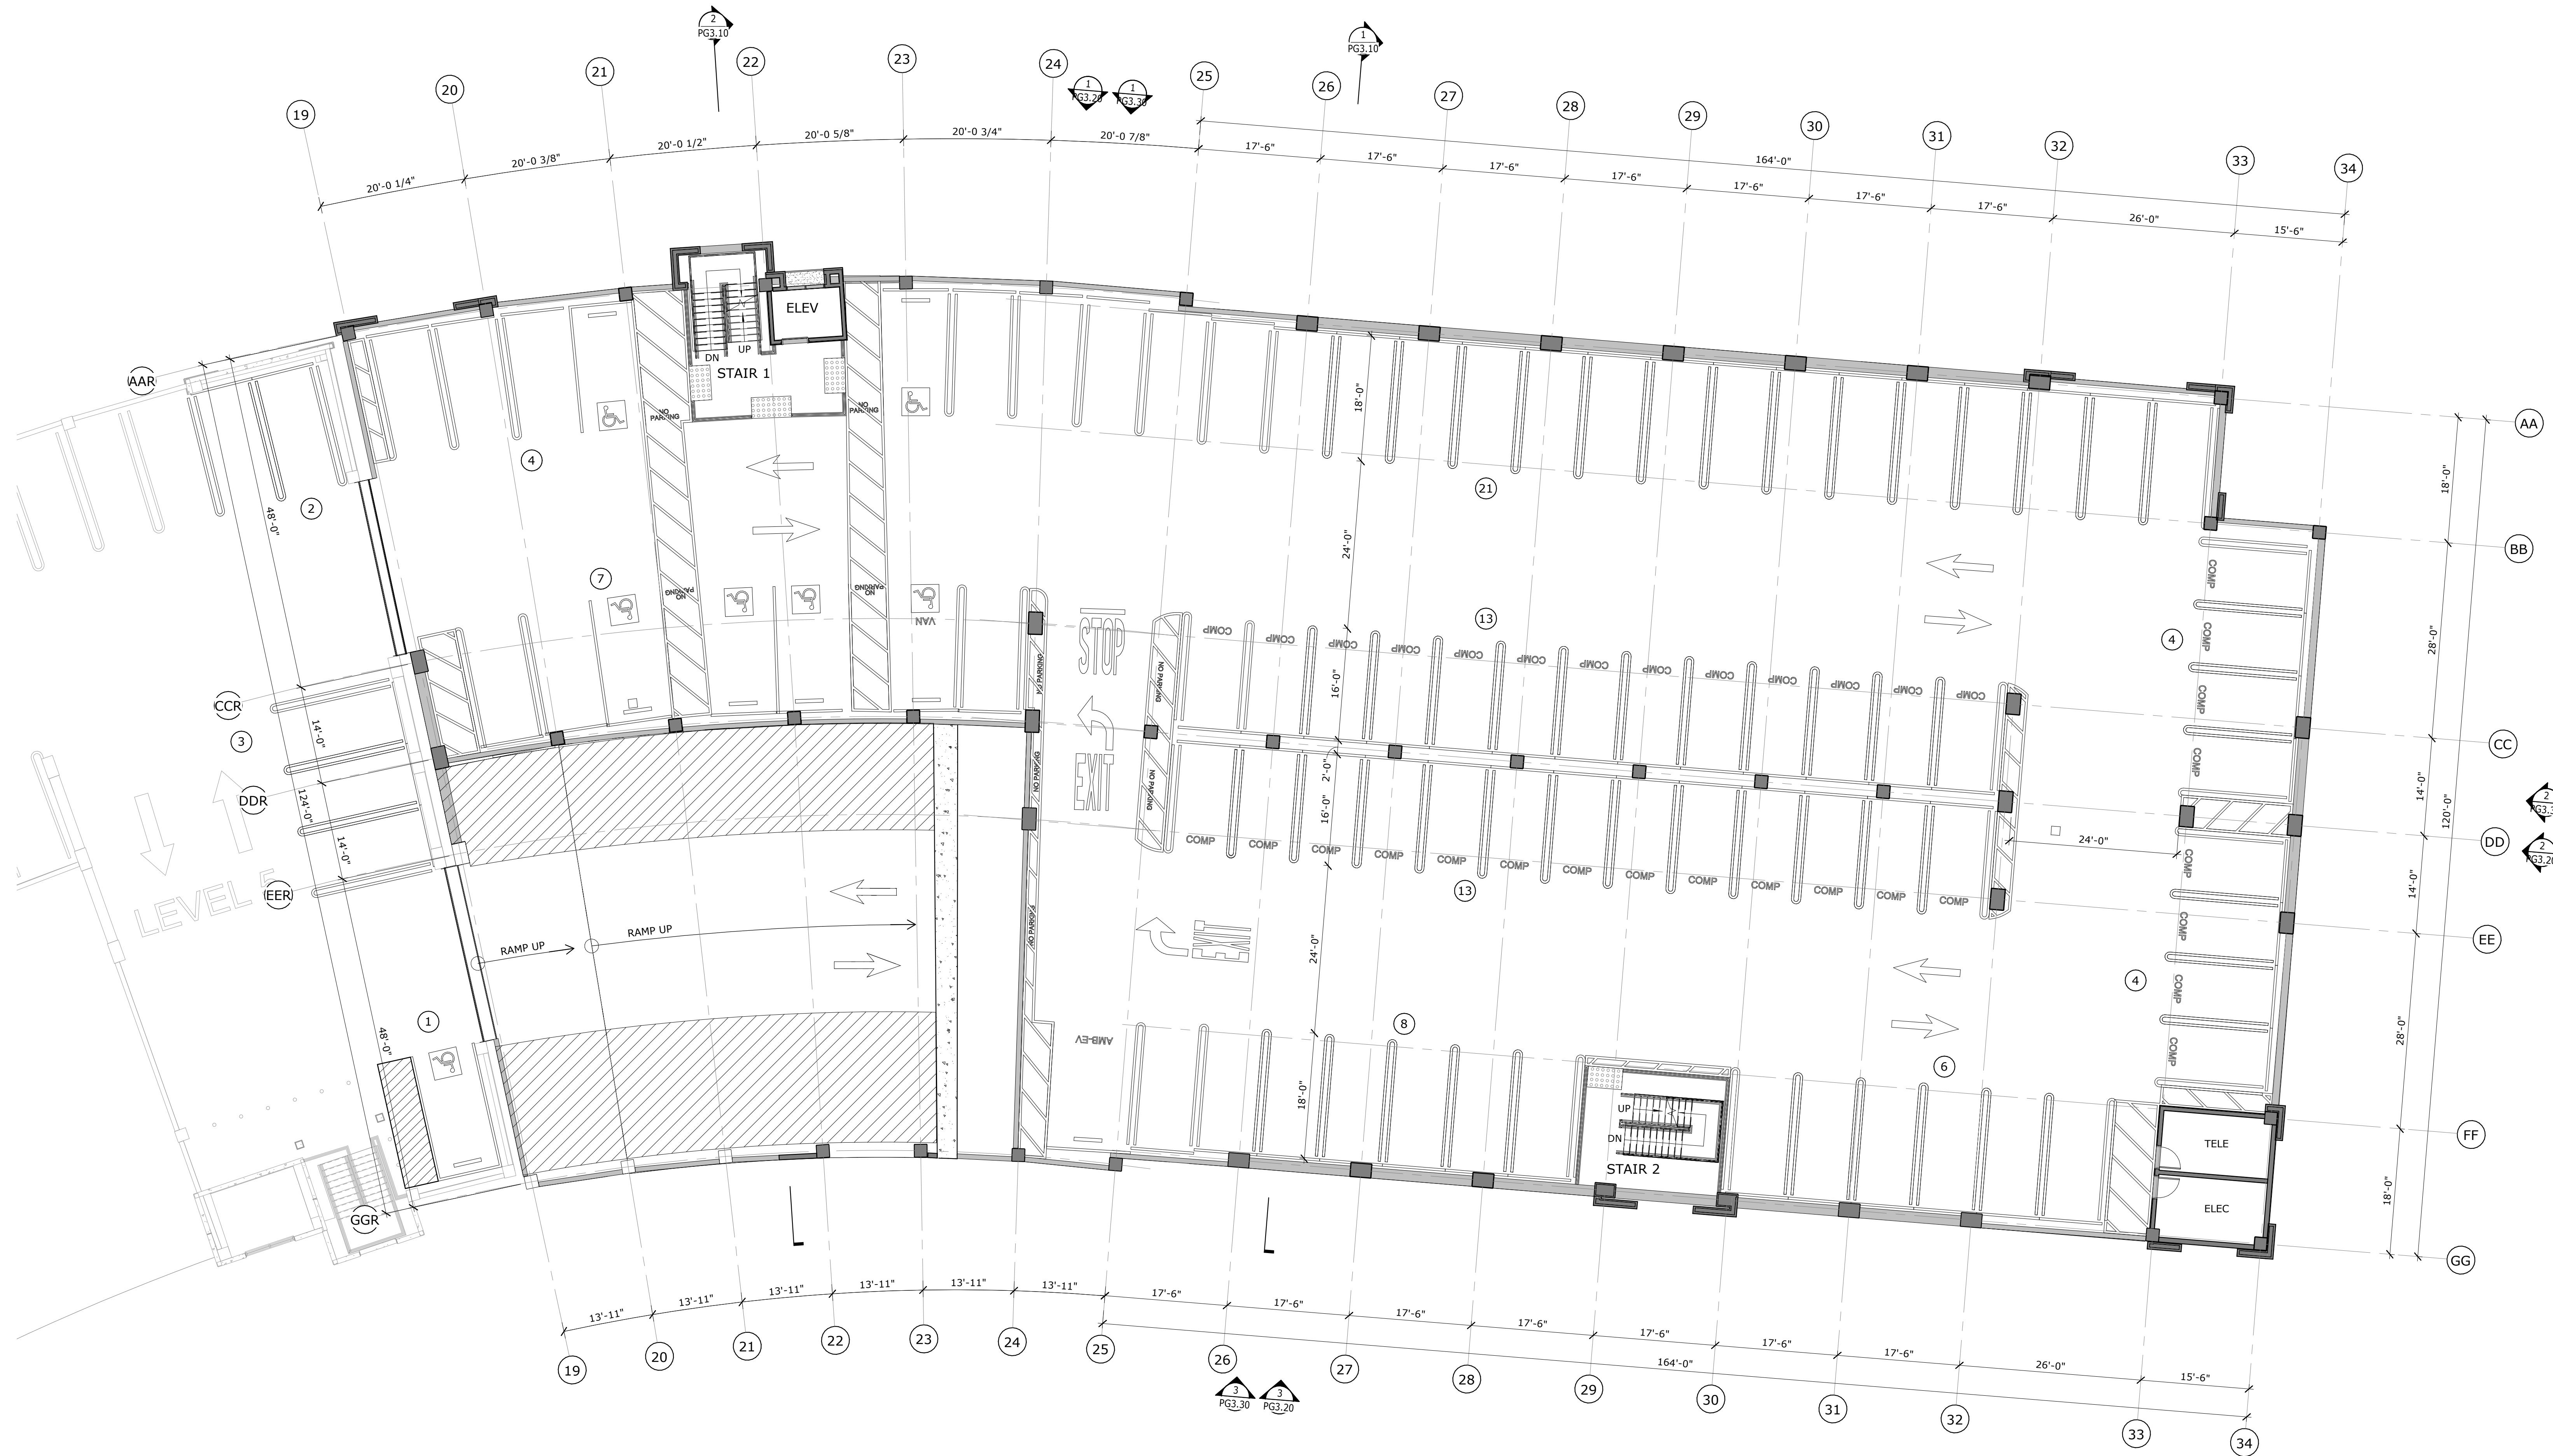

CITY APPROVAL STAMP

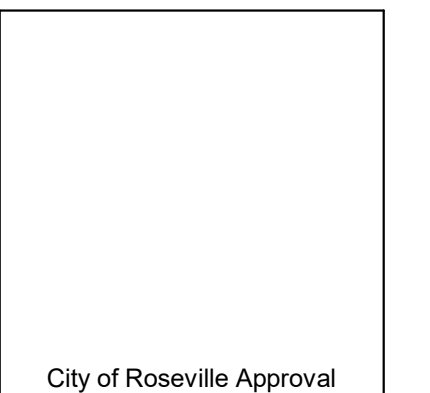

THIS DRAWING IS NOT FINAL OR TO BE
USED FOR CONSTRUCTION UNTIL IT IS
SIGNED BY THE ARCHITECT/ENGINEER

REVISION BY DATE

SUTTER HEALTH
PARKING GARAGE 12
EXPANSION

12 MEDICAL PLAZA
ROSEVILLE, CA 95661


LEVEL 05 FLOOR PLAN




C1009.00
AS SHOWN
03/28/2022

PG2.51

1 LEVEL 05-FLOOR PLAN
3/32" = 1'-0"

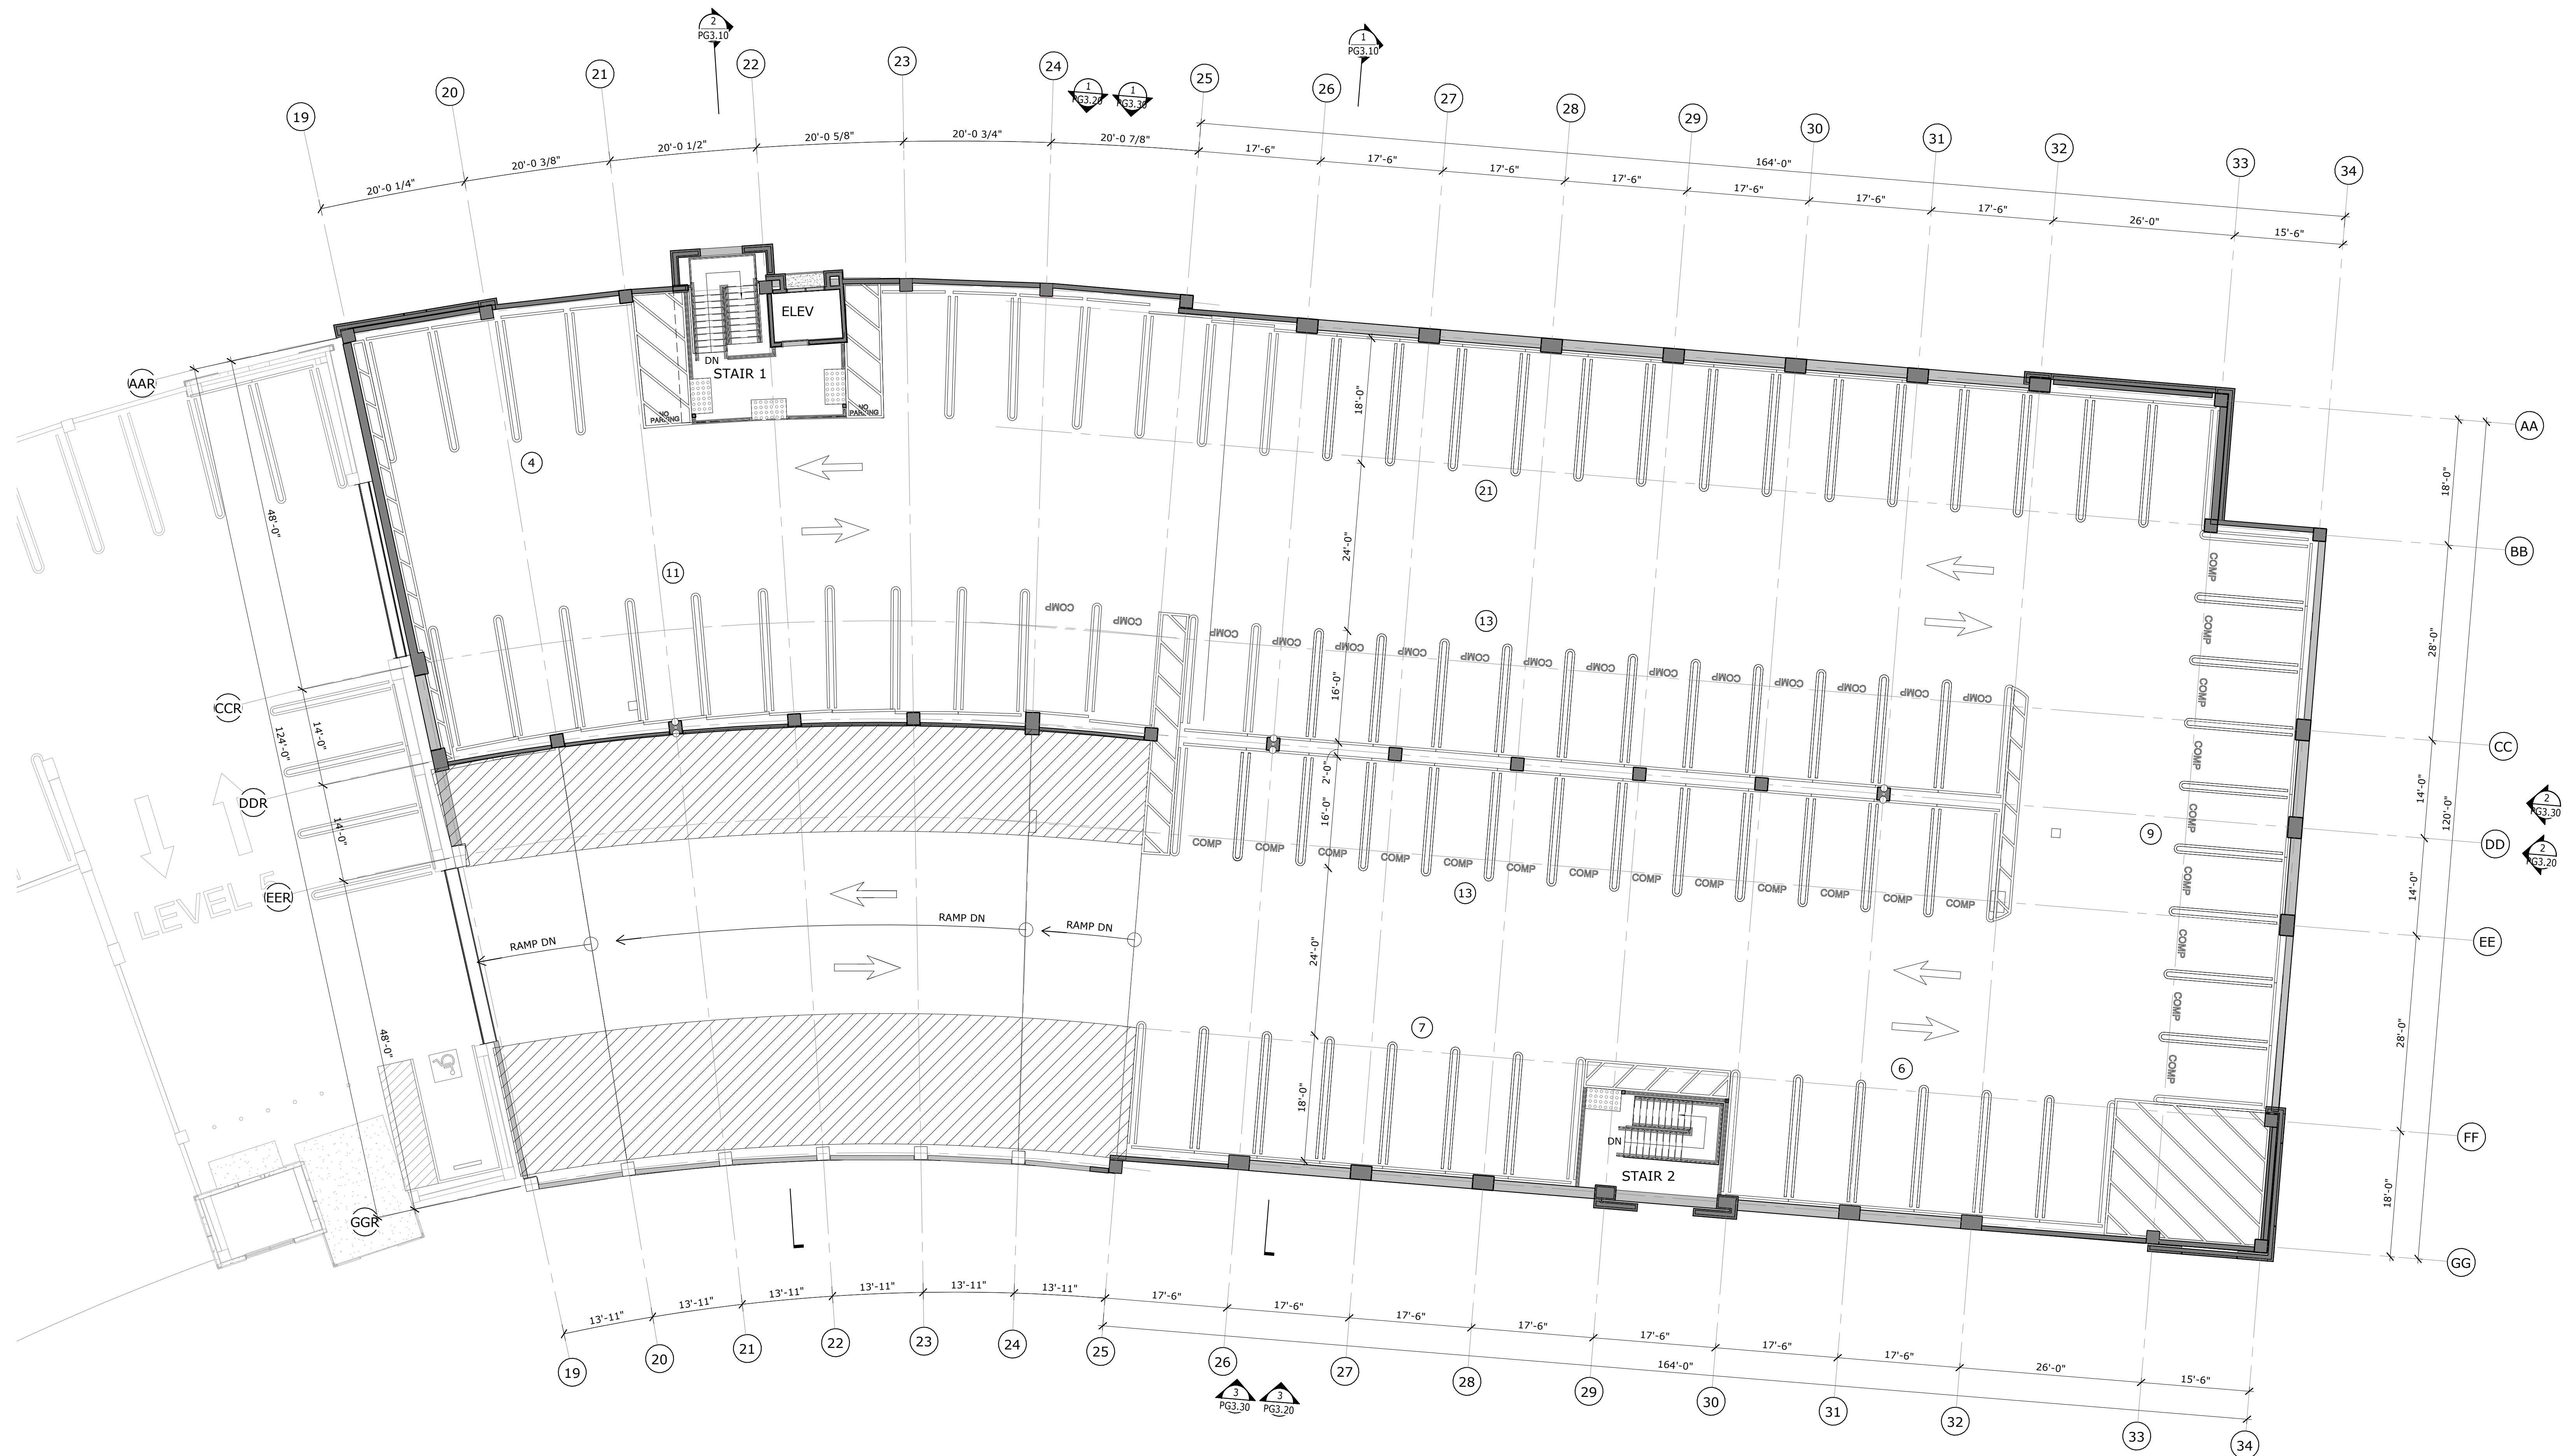

CITY APPROVAL STAMP

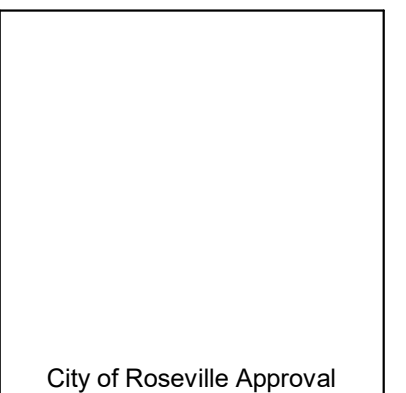

THIS DRAWING IS NOT FINAL OR TO BE
USED FOR CONSTRUCTION UNTIL IT IS
SIGNED BY THE ARCHITECT/ENGINEER

REVISION BY DATE

SUTTER HEALTH
PARKING GARAGE 12
EXPANSION

12 MEDICAL PLAZA
ROSEVILLE, CA 95661

LEVEL 06 FLOOR PLAN




C1009.00
AS SHOWN
03/28/2022


PG2.61

1 LEVEL 06-FLOOR PLAN
3/32" = 1'-0"

C:\Users\mmwalski\Documents\Local Files\C1009.00-Sutter Parking Garage 2 Expansion_A21_mwalski032922.rvt 3/29/2022 11:28:17 AM

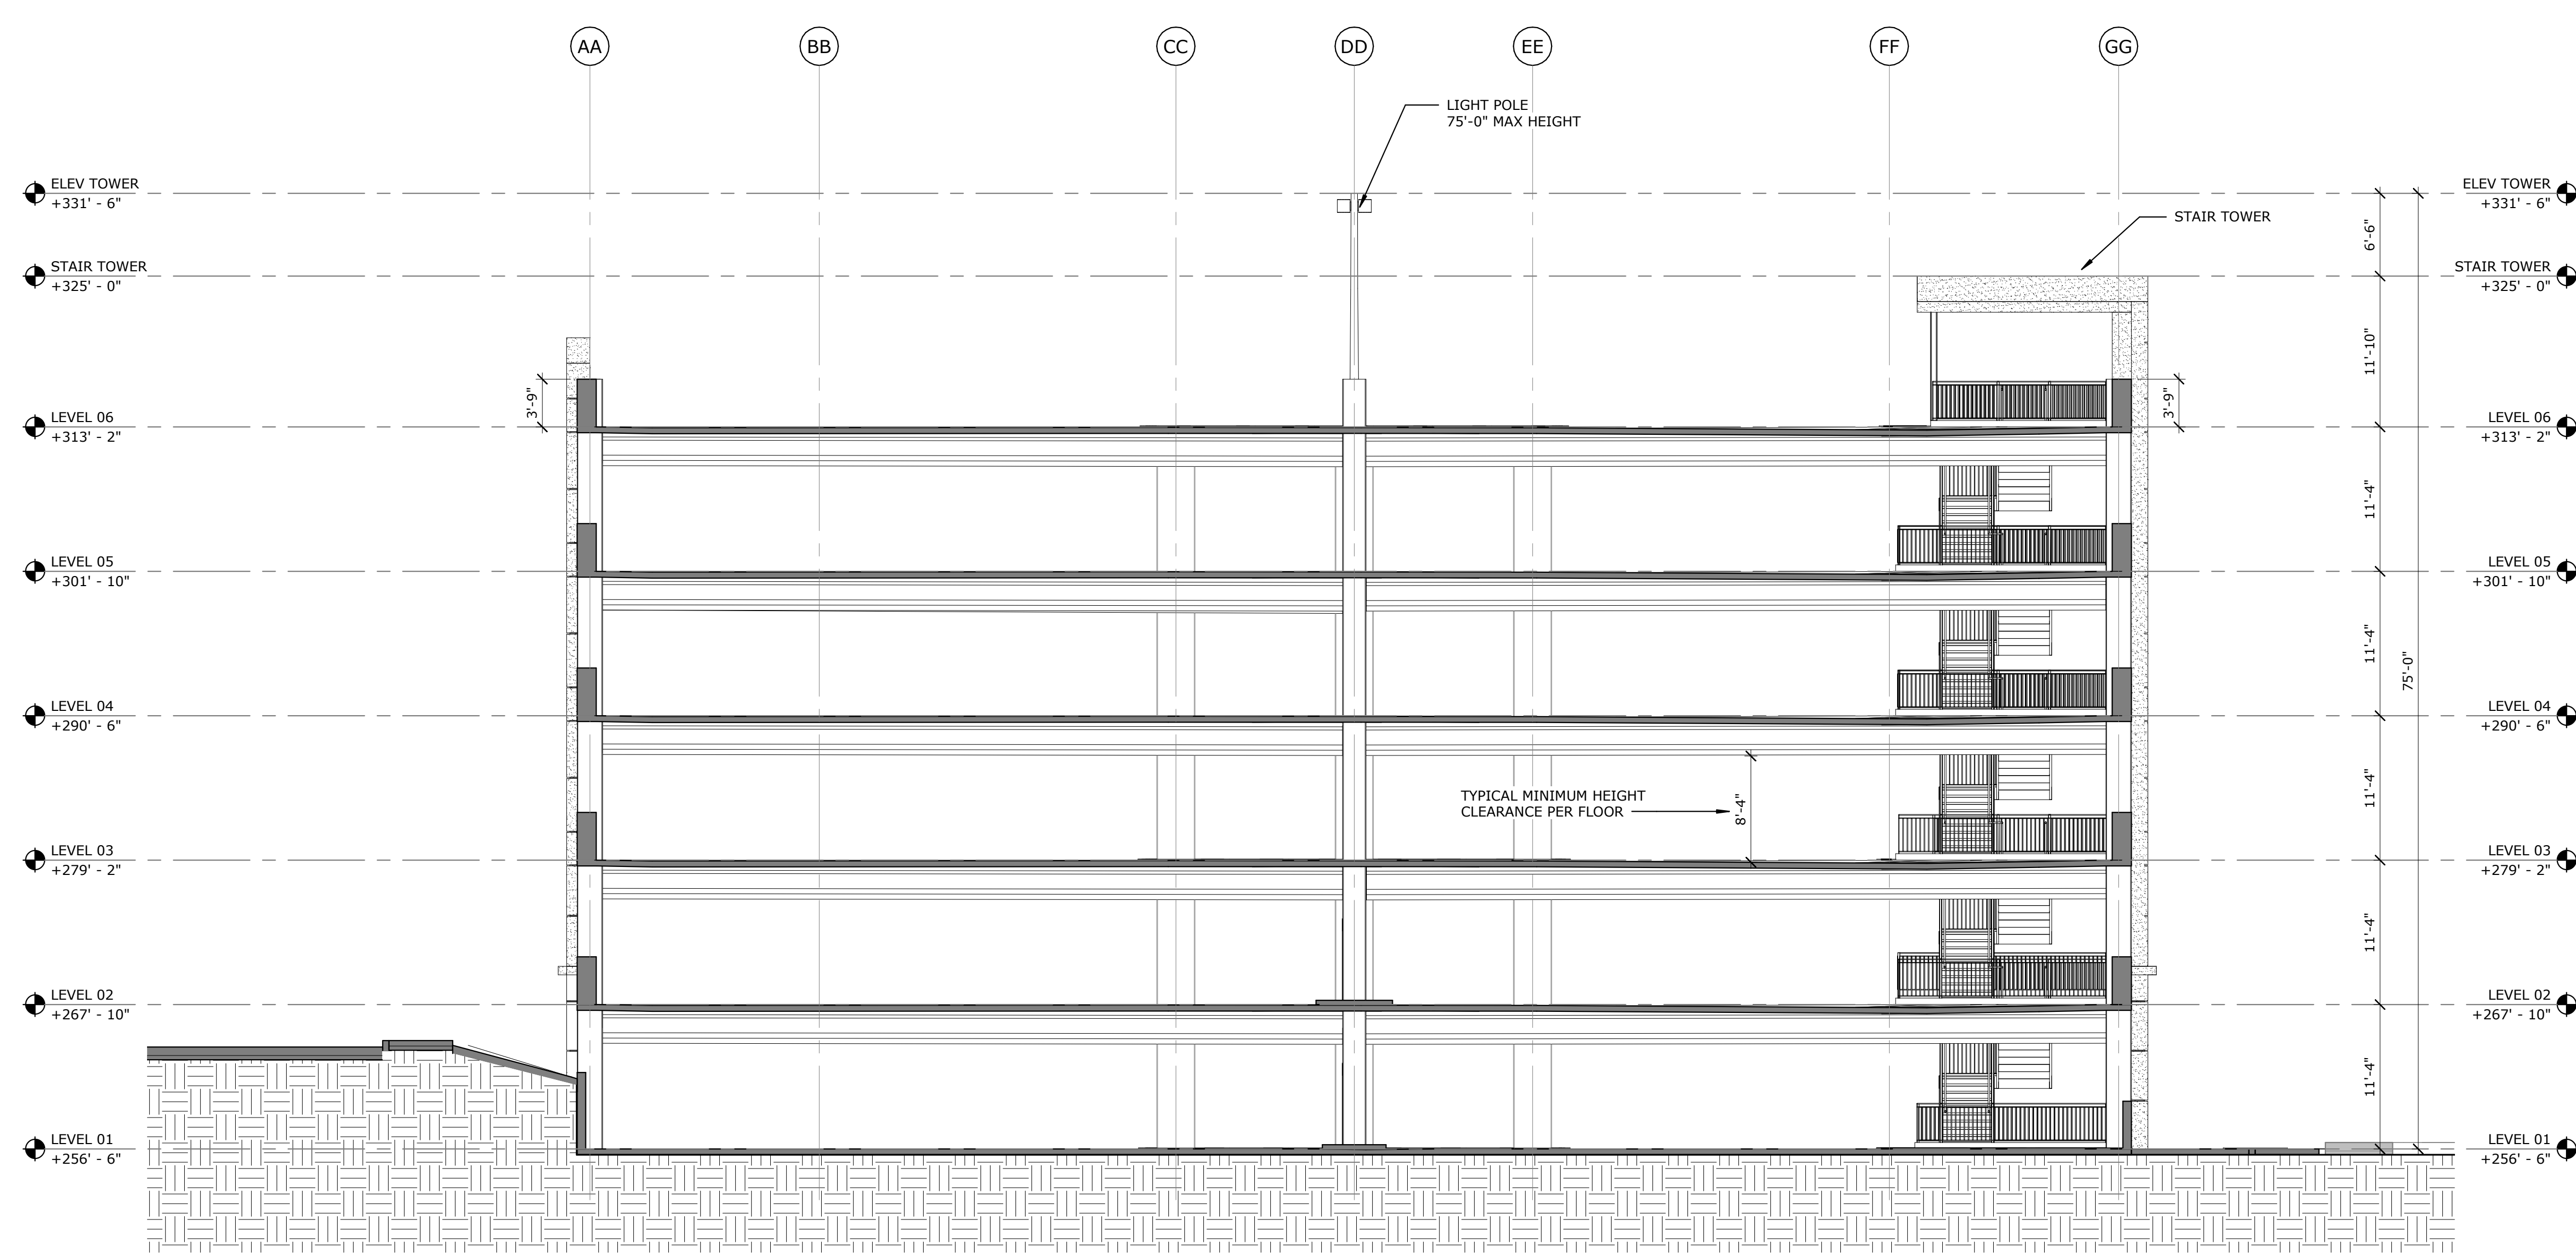


1 BUILDING SECTION 1
1/8" = 1'-0"

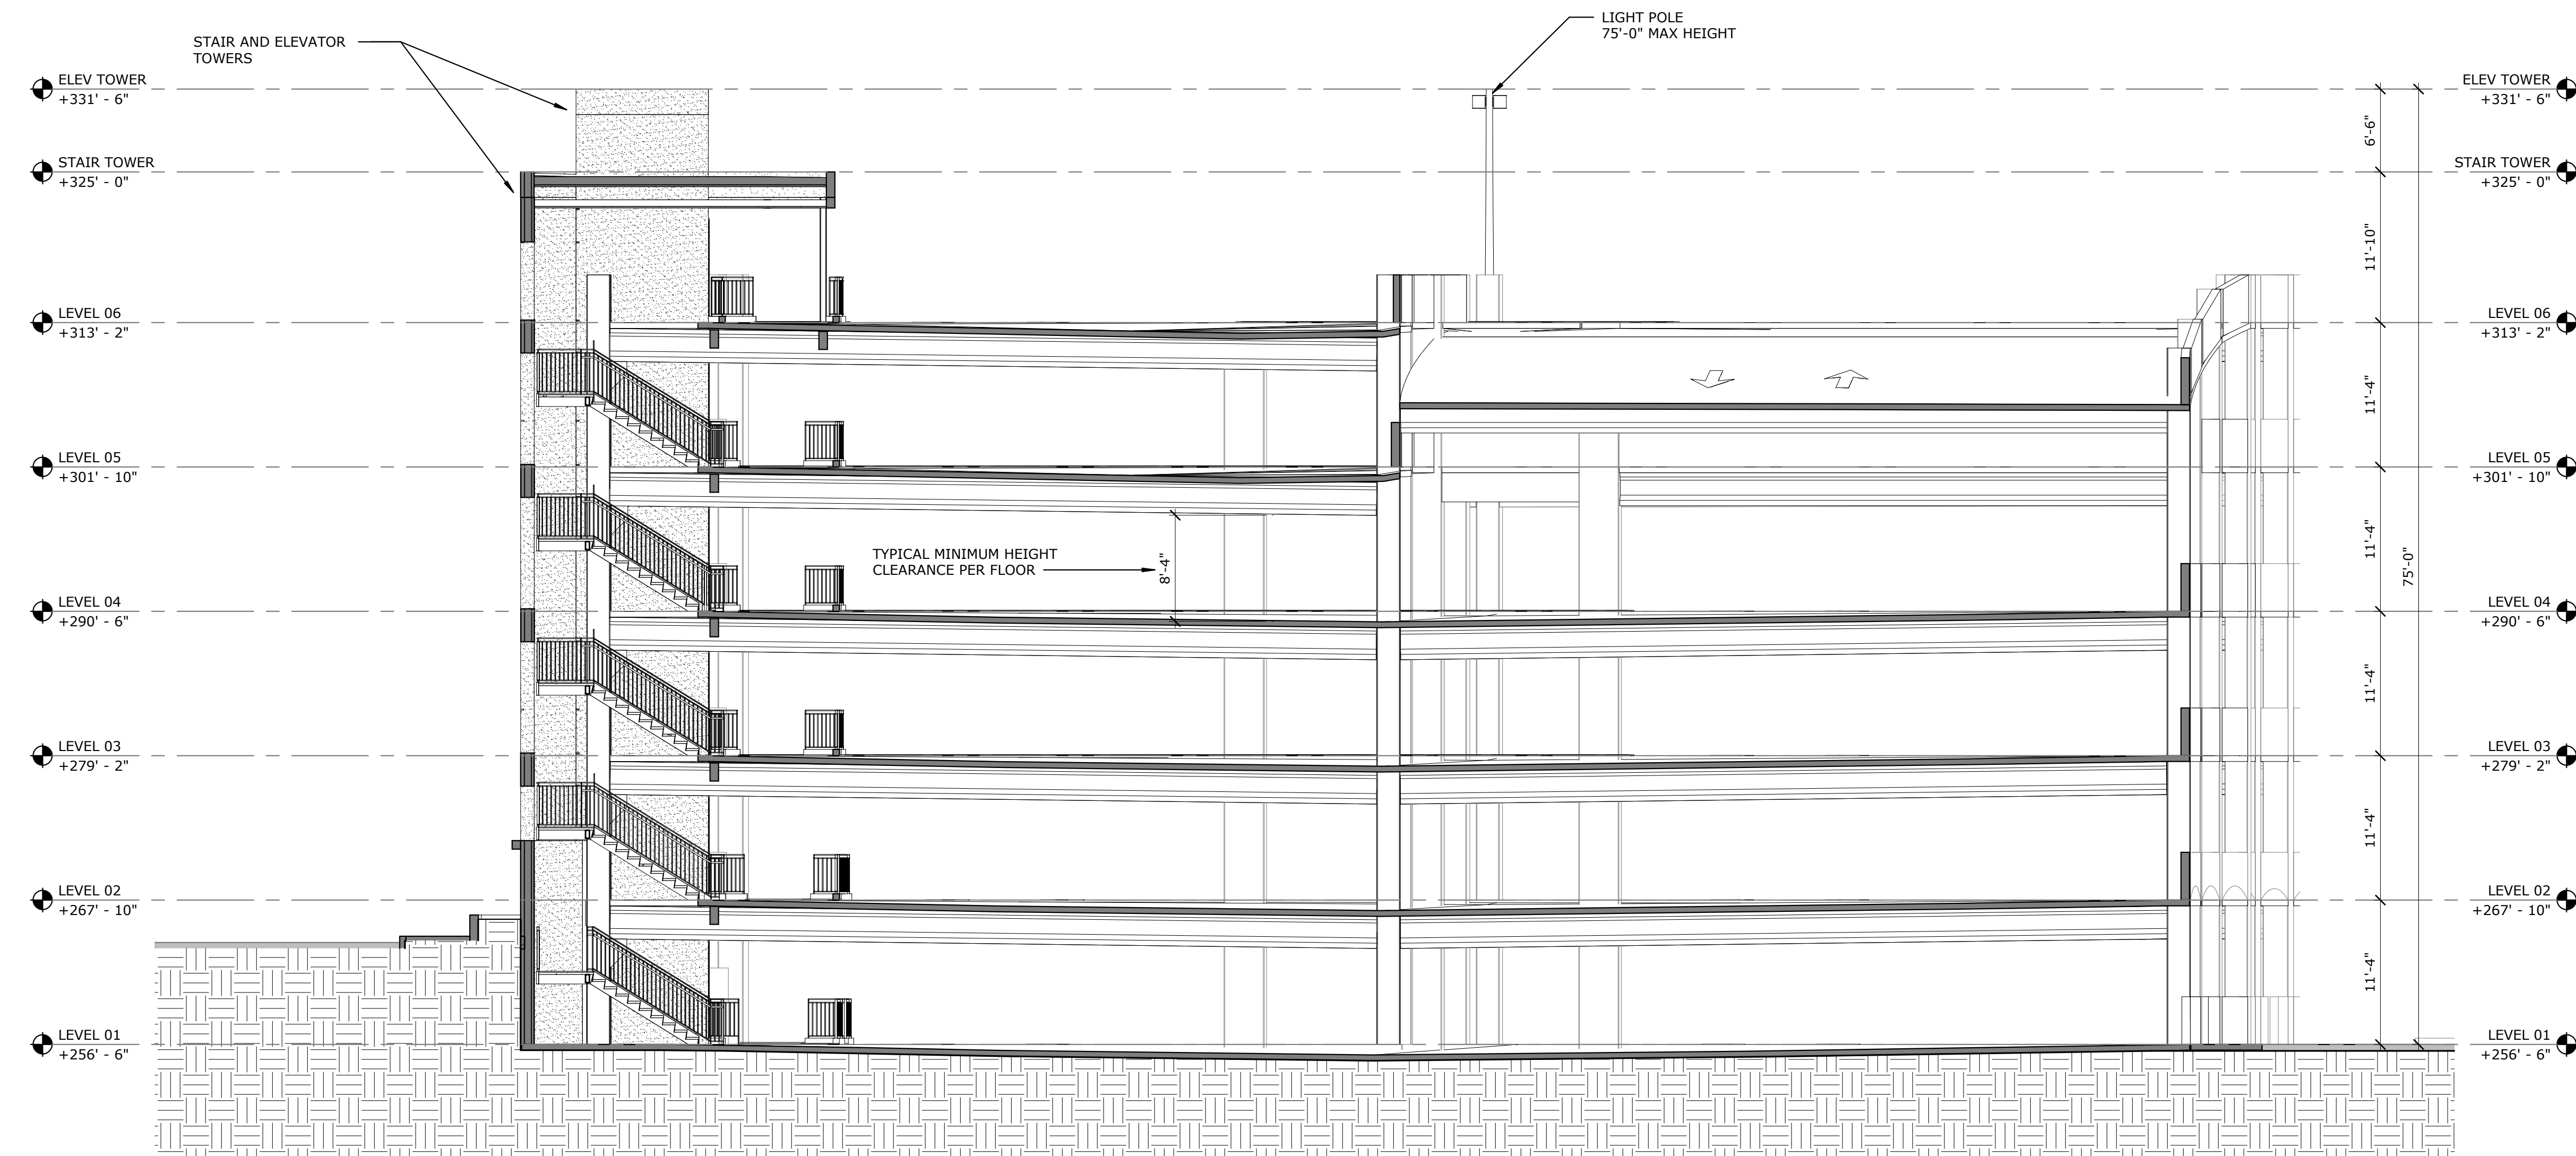

2 BUILDING SECTION 2
1/8" = 1'-0"

CITY APPROVAL STAMP

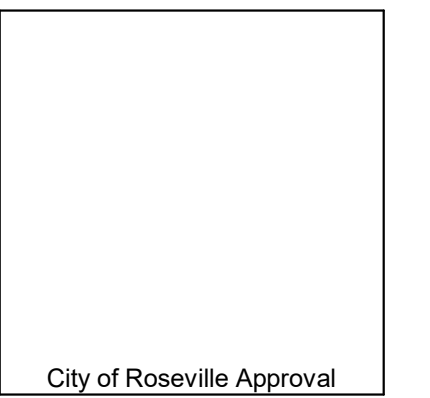


THIS DRAWING IS NOT FINAL OR TO BE
USED FOR CONSTRUCTION UNTIL IT IS
SIGNED BY THE ARCHITECT/ENGINEER

REVISION BY DATE


SUTTER HEALTH
PARKING GARAGE 12
EXPANSION

12 MEDICAL PLAZA
ROSEVILLE, CA 95661


BUILDING SECTIONS

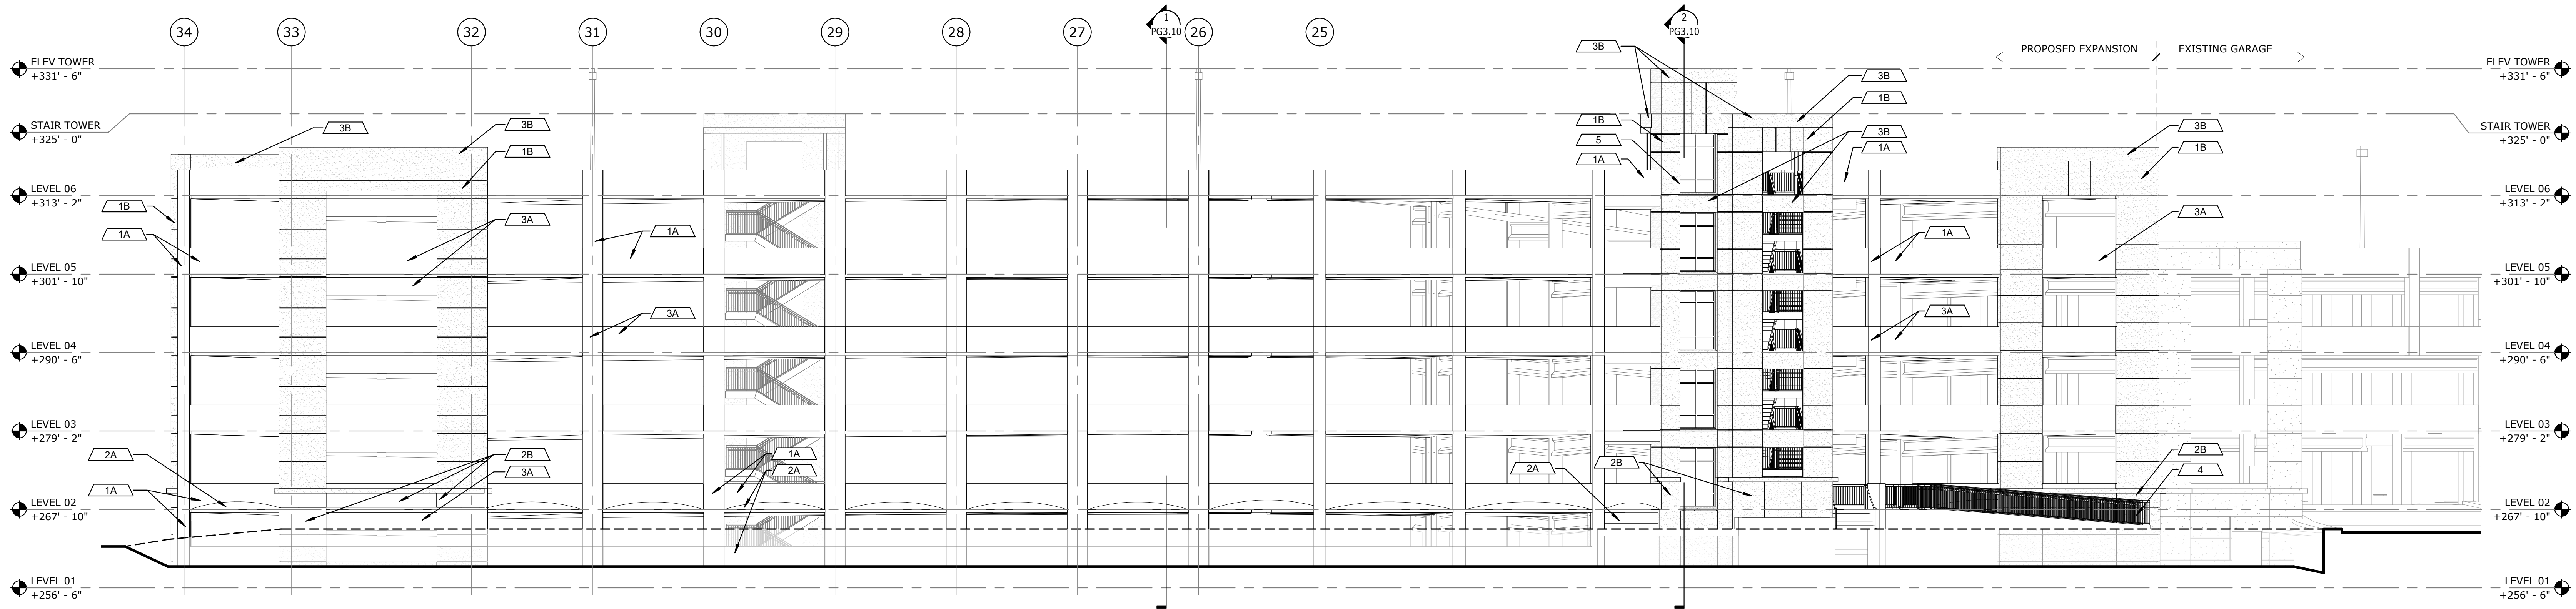

1 BUILDING ELEVATION - NORTH
3/32" = 1'-0"

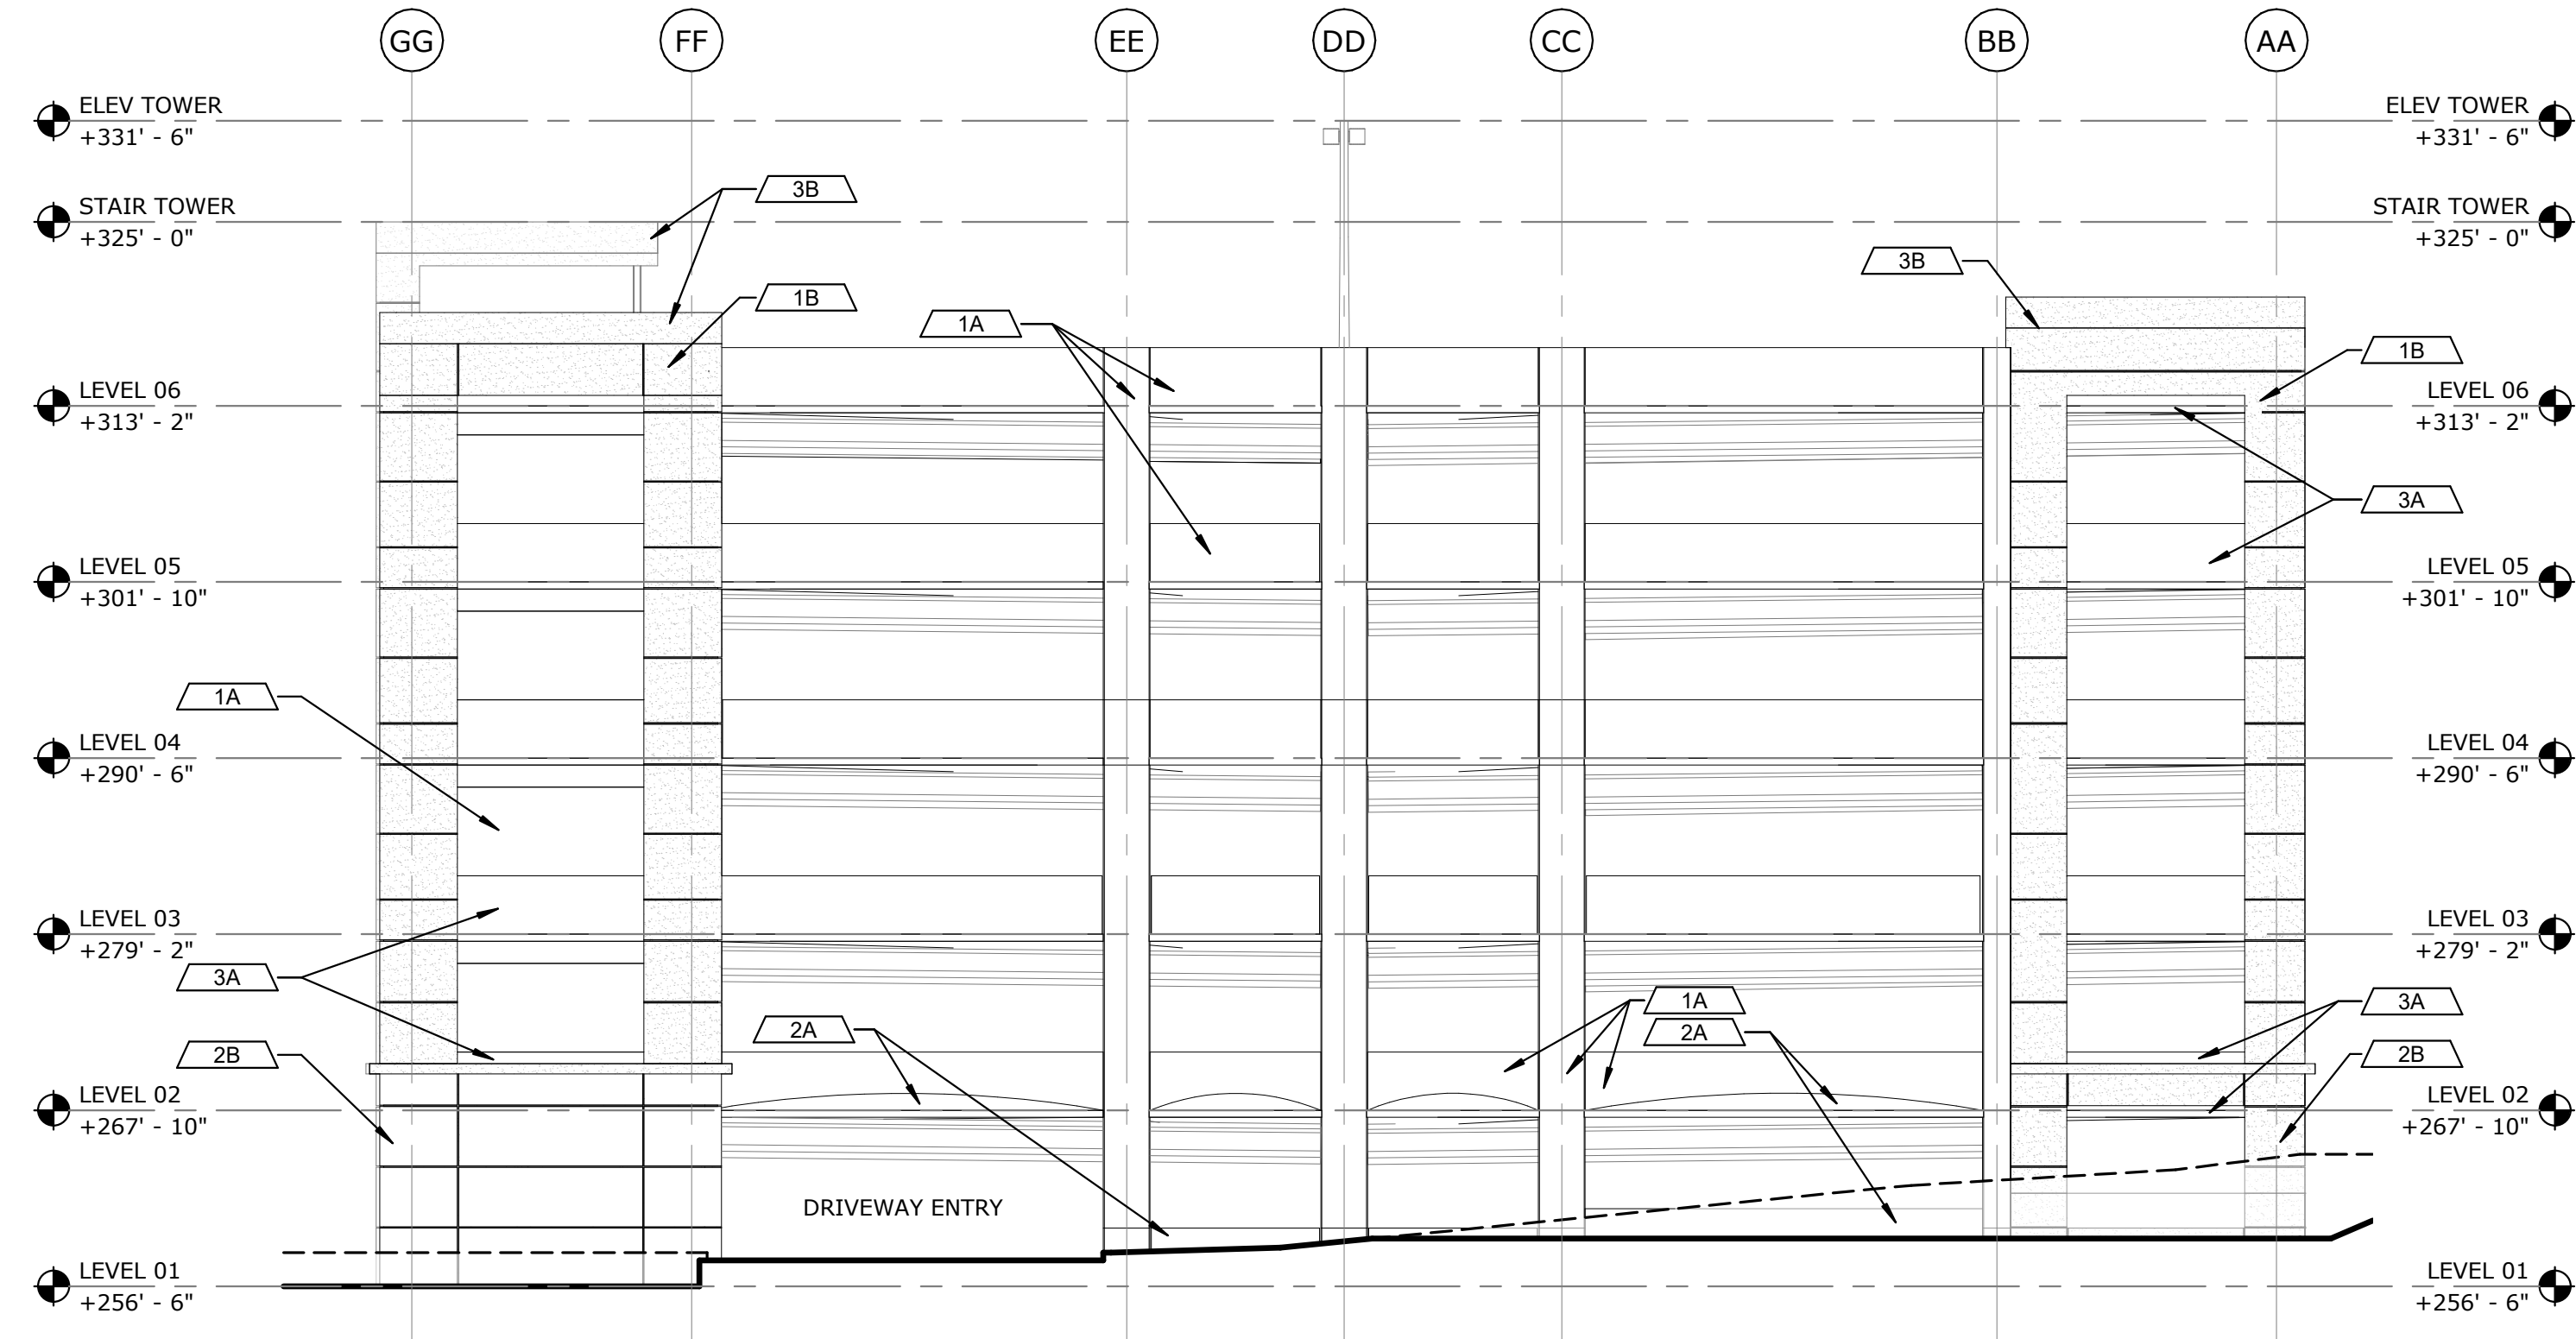

2 BUILDING ELEVATION - EAST
3/32" = 1'-0"

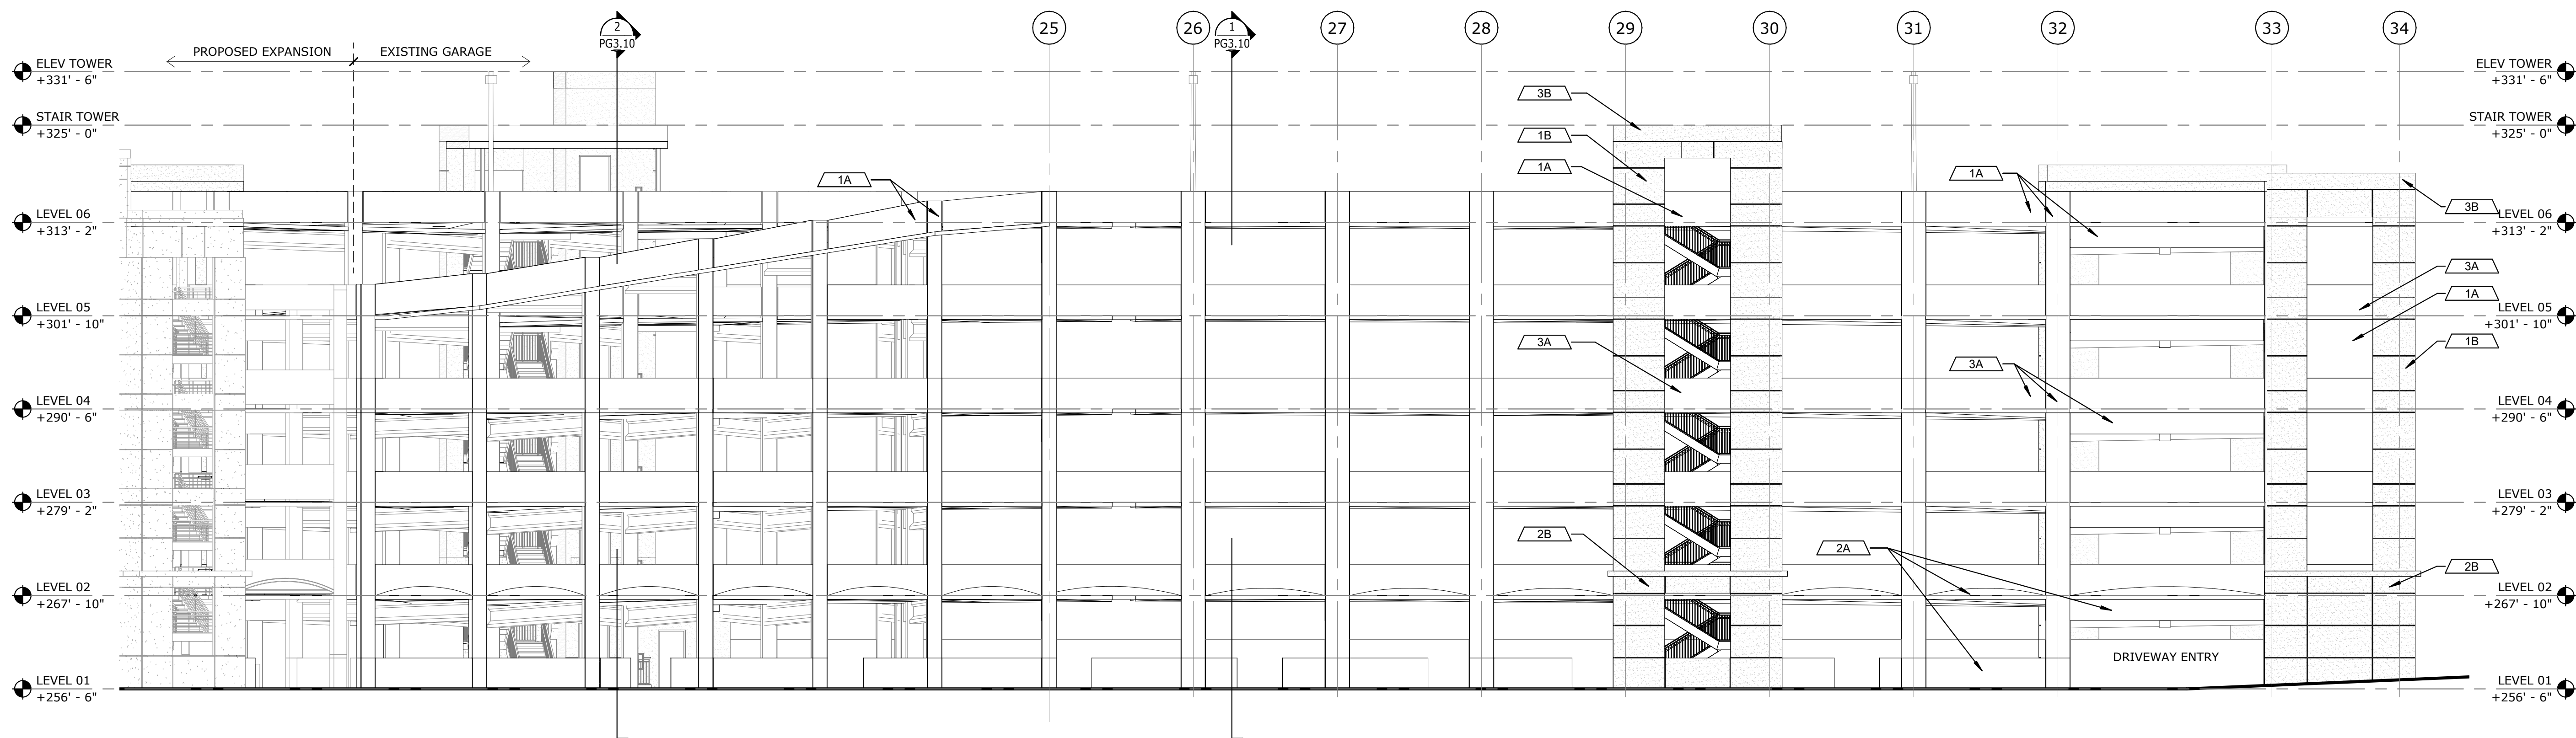


3 BUILDING ELEVATION - SOUTH
3/32" = 1'-0"

EXTERIOR FINISH LEGEND

- 1A PAINTED CONCRETE PANEL - BEIGE
- 1B PAINTED EIFS FINISH - BEIGE
- 2A PAINTED CONCRETE PANEL - BROWN
- 2B PAINTED EIFS FINISH - BROWN
- 3A PAINTED CONCRETE PANEL - GREEN
- 3B PAINTED EIFS FINISH - GREEN
- 4 PAINTED METAL FINISH - CHARCOAL GRAY
- 5 CLEAR ANODIZED ALUMINUM STOREFRONT

CITY APPROVAL STAMP

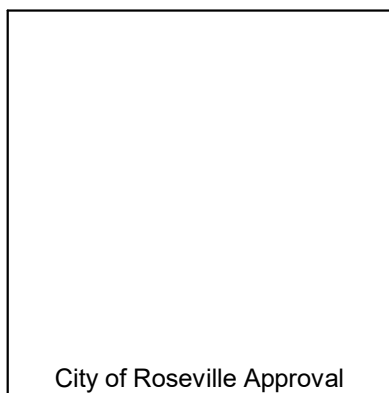

THIS DRAWING IS NOT FINAL OR TO BE
USED FOR CONSTRUCTION UNTIL IT IS
SIGNED BY THE ARCHITECT/ENGINEER

REVISION BY DATE


SUTTER HEALTH
PARKING GARAGE 12
EXPANSION

12 MEDICAL PLAZA
ROSEVILLE, CA 95661

BUILDING EXPANSION
ELEVATIONS



C1009.00
AS SHOWN
03/11/2022

PG3.20

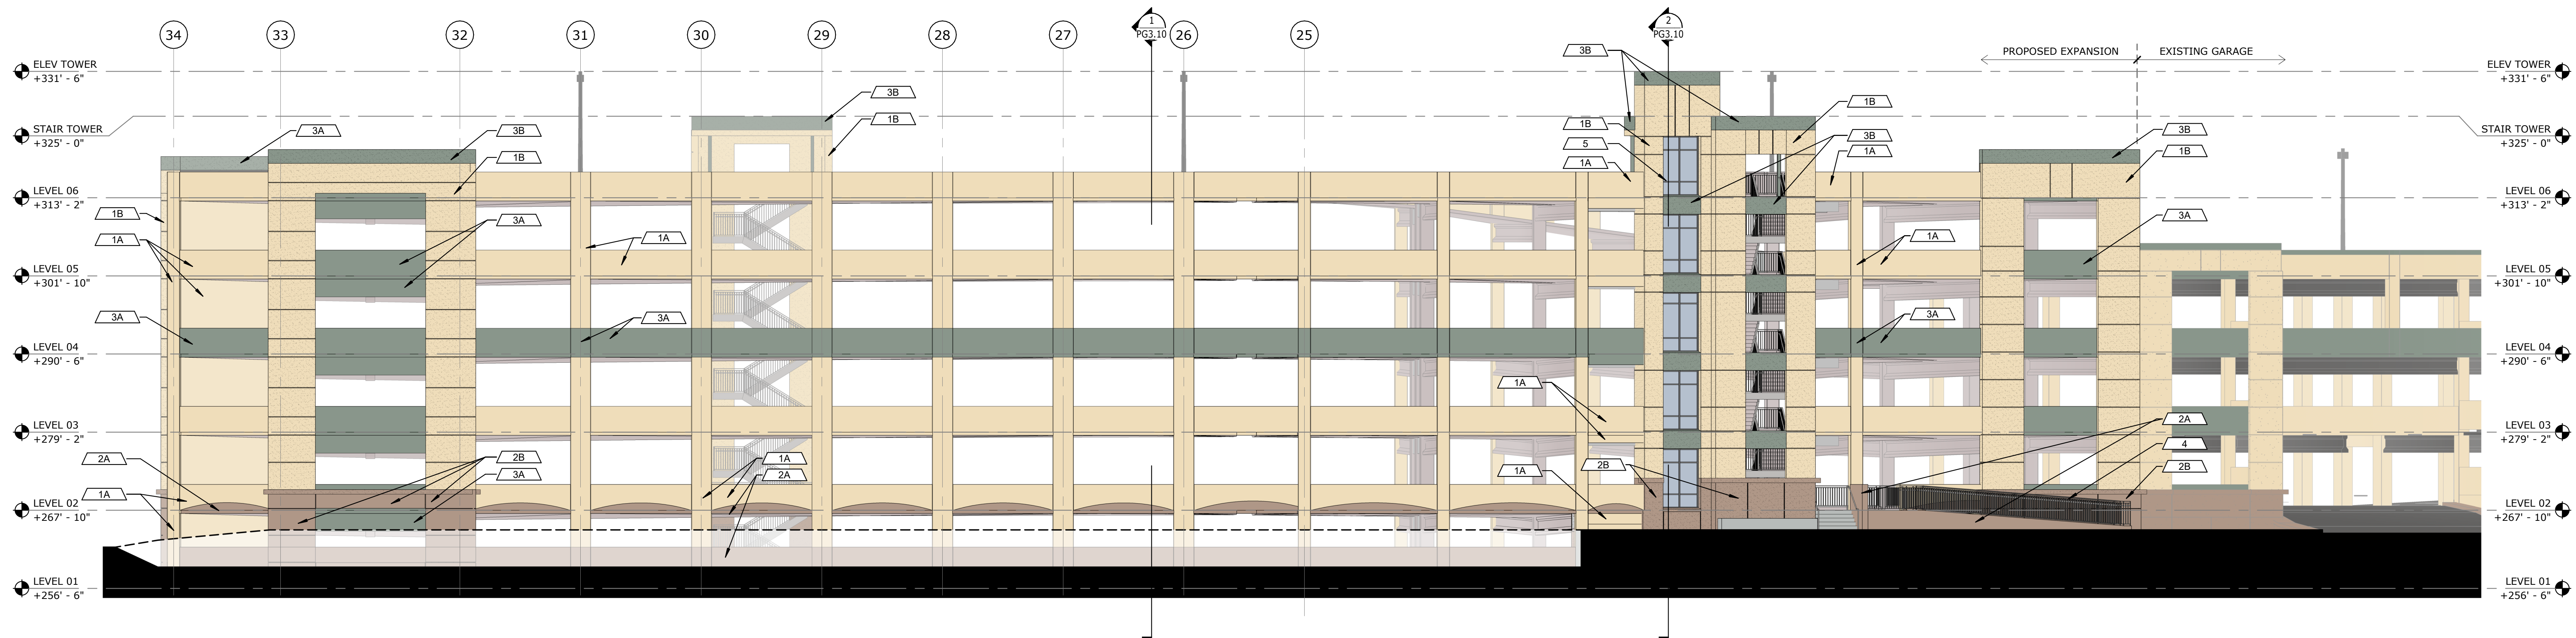

1 BUILDING ELEVATION - NORTH COLOR - ENTITLEMENTS
3/32" = 1'-0"

CITY APPROVAL STAMP

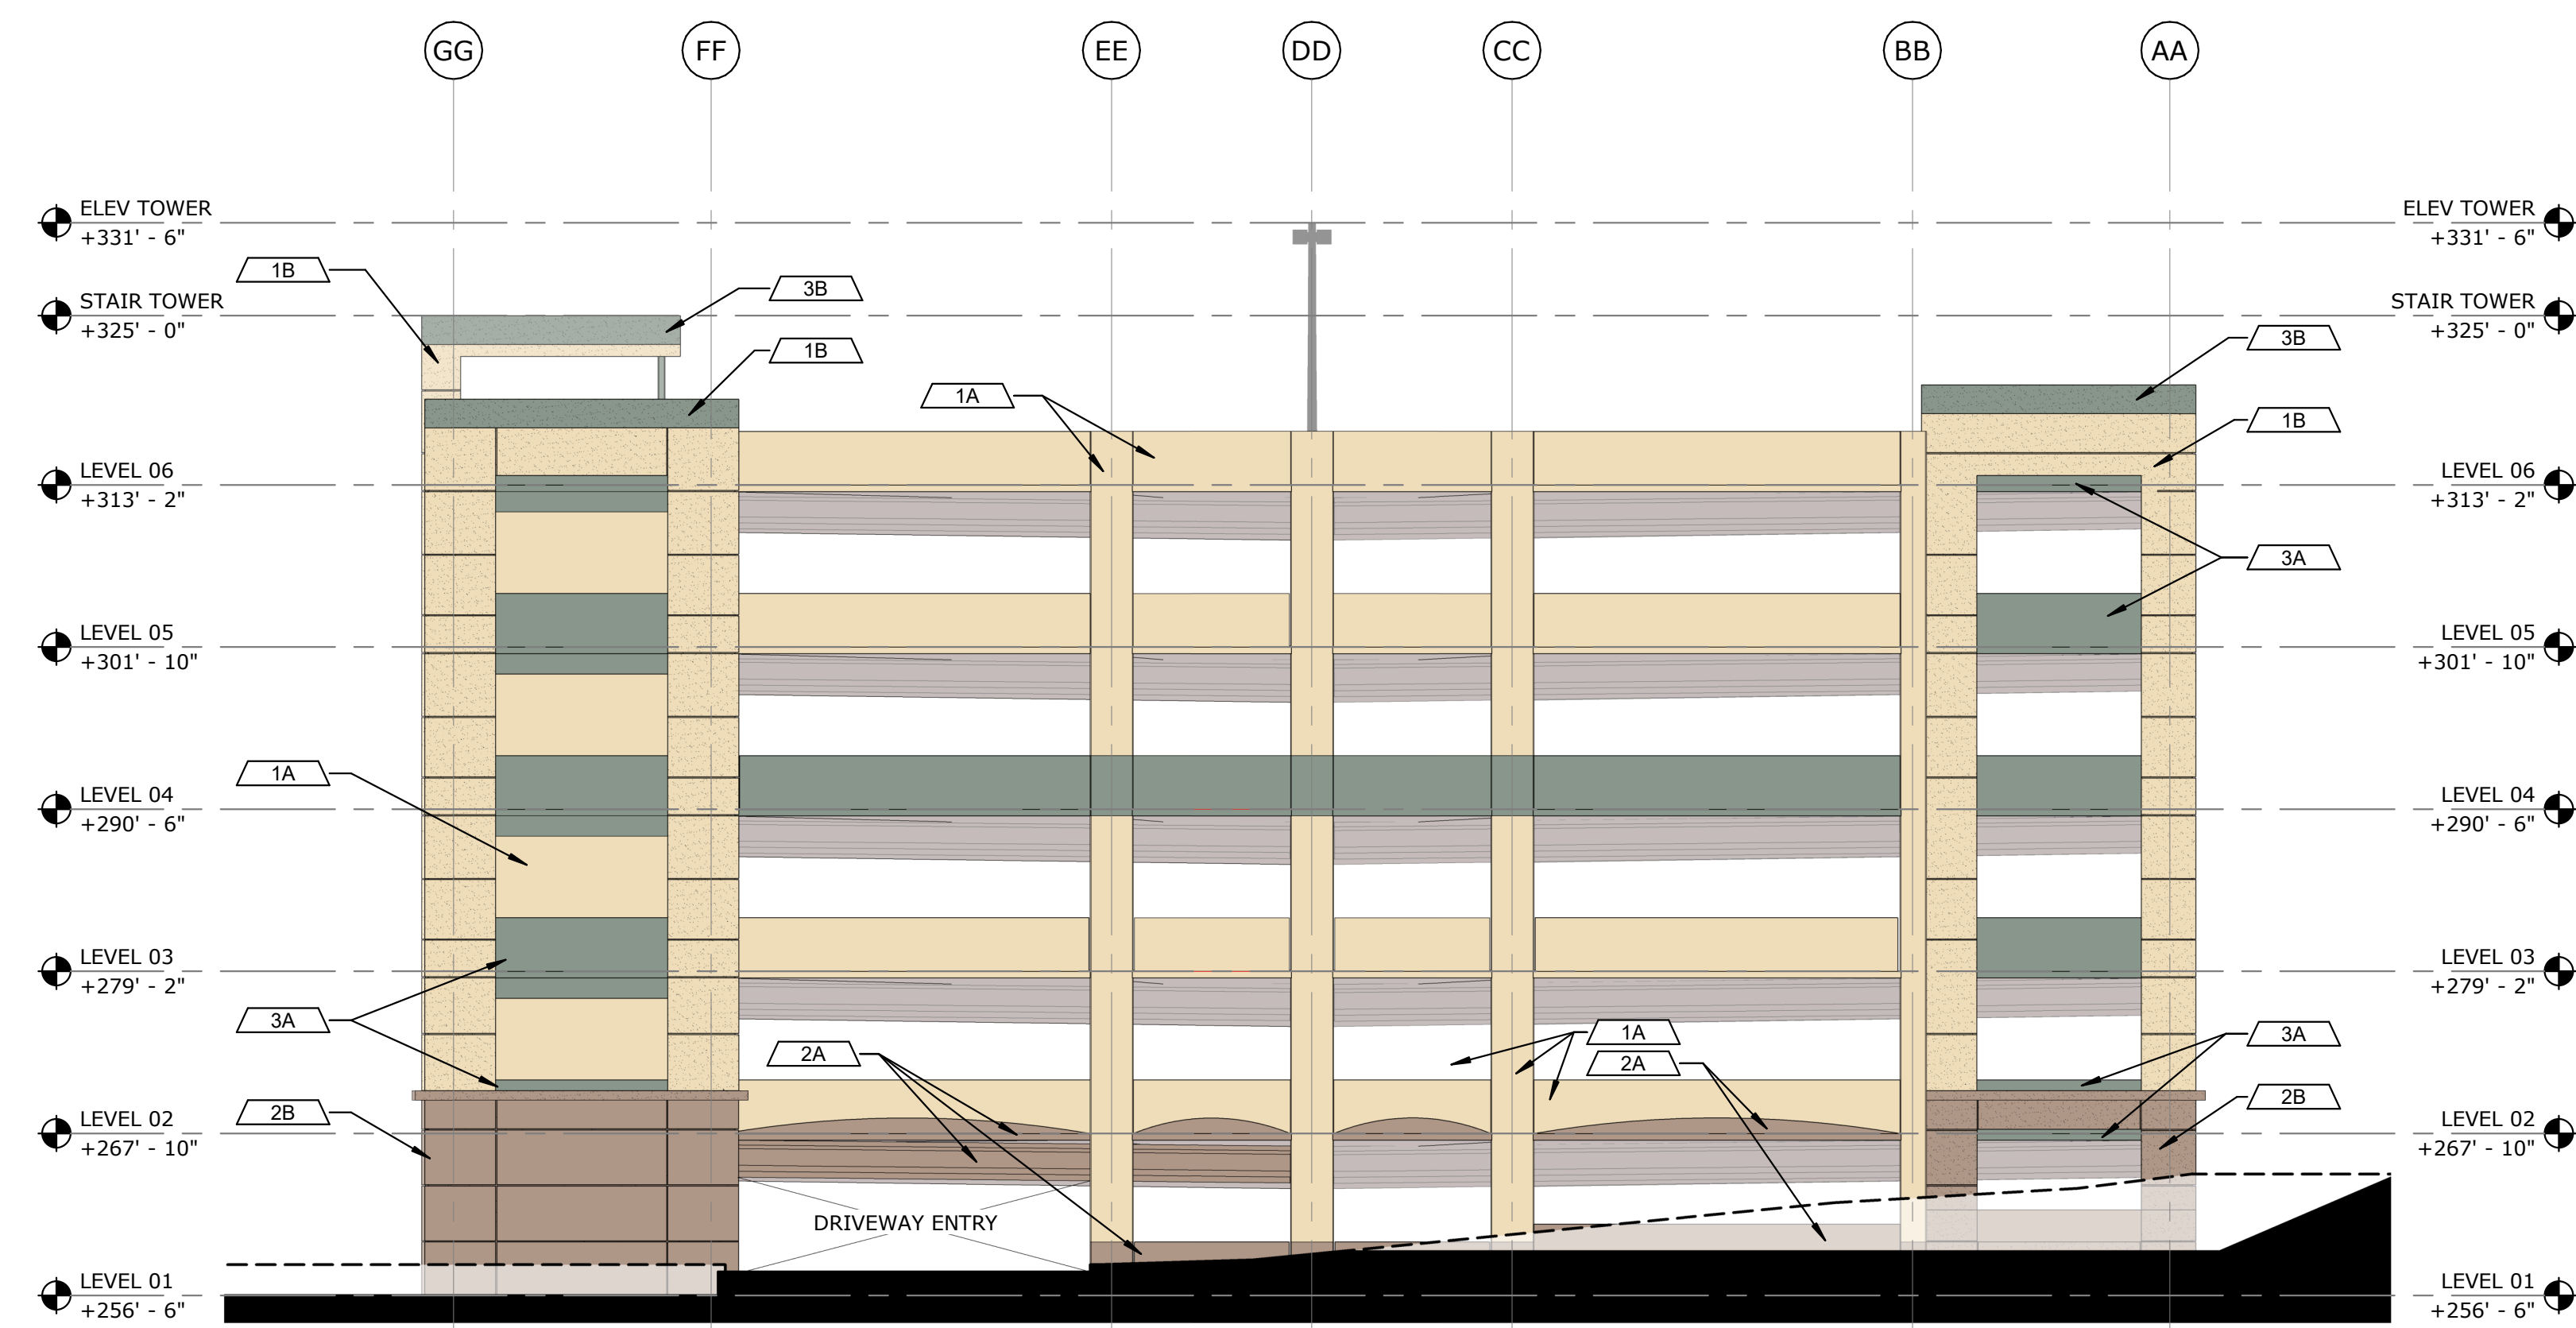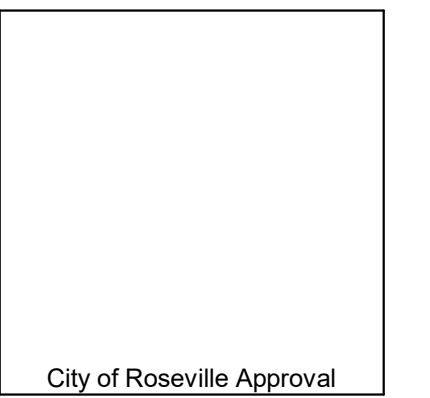


EXTERIOR FINISH LEGEND

1A	PAINTED CONCRETE PANEL - BEIGE
1B	PAINTED EIFS FINISH - BEIGE
2A	PAINTED CONCRETE PANEL - BROWN
2B	PAINTED EIFS FINISH - BROWN
3A	PAINTED CONCRETE PANEL - GREEN
3B	PAINTED EIFS FINISH - GREEN
4	PAINTED METAL FINISH - CHARCOAL GRAY
5	CLEAR ANODIZED ALUMINUM STOREFRONT

THIS DRAWING IS NOT FINAL OR TO BE
USED FOR CONSTRUCTION UNTIL IT IS
SIGNED BY THE ARCHITECT/FIRM/OWNER

2 BUILDING ELEVATION - EAST COLOR - ENTITLEMENTS
3/32" = 1'-0"

REVISION BY DATE

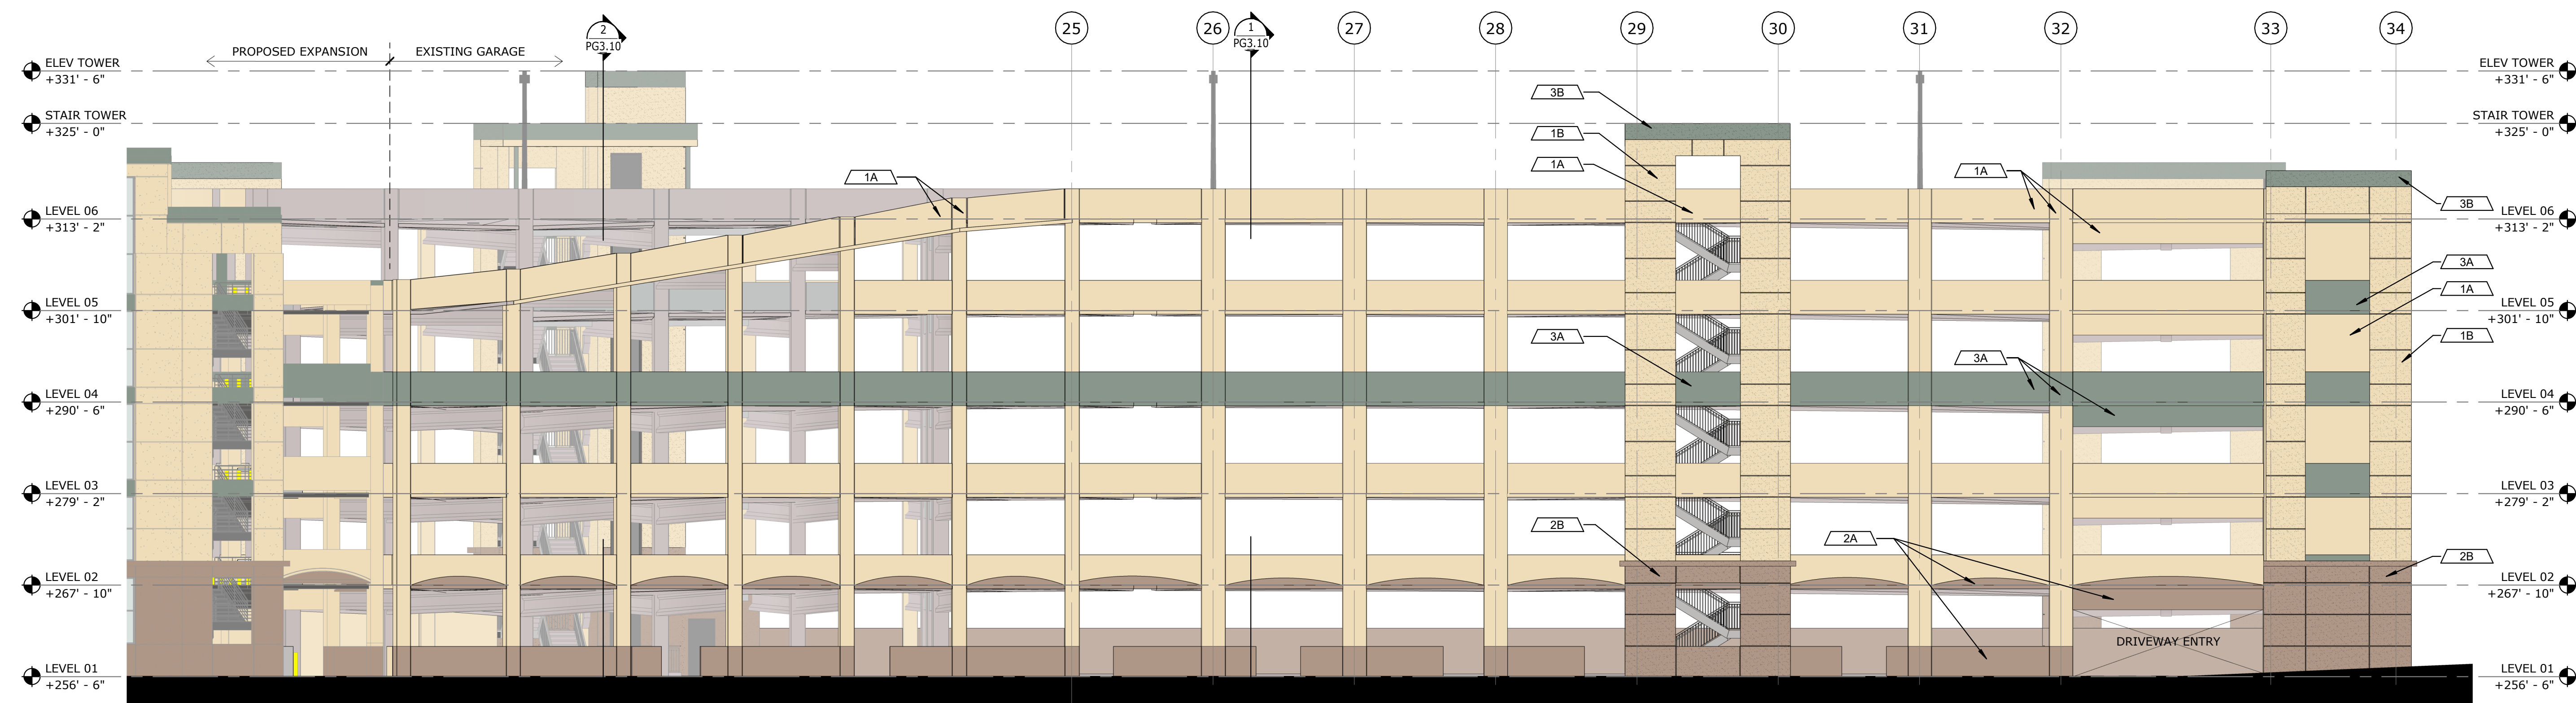

3 BUILDING ELEVATION - SOUTH COLOR - ENTITLEMENTS
3/32" = 1'-0"

SUTTER HEALTH
PARKING GARAGE 12
EXPANSION

12 MEDICAL PLAZA
ROSEVILLE, CA 95661

BUILDING EXPANSION COLOR
ELEVATIONS

C1009.00
AS SHOWN
03/28/2022

PG3.30

LICENSE #471434


signature

City of Roseville Approval

REVISION	BY	DATE
----------	----	------

LEVEL 06 ELECTRICAL PLAN

- 1) VERIFY EXACT LOCATION OF ALL ROOFTOP FLIGHT LIGHTS PRIOR TO ROUGH-IN.
- 2) STAIRWAY LIGHTING CIRCUIT TO CONTINUE DOWNSTAIRS.

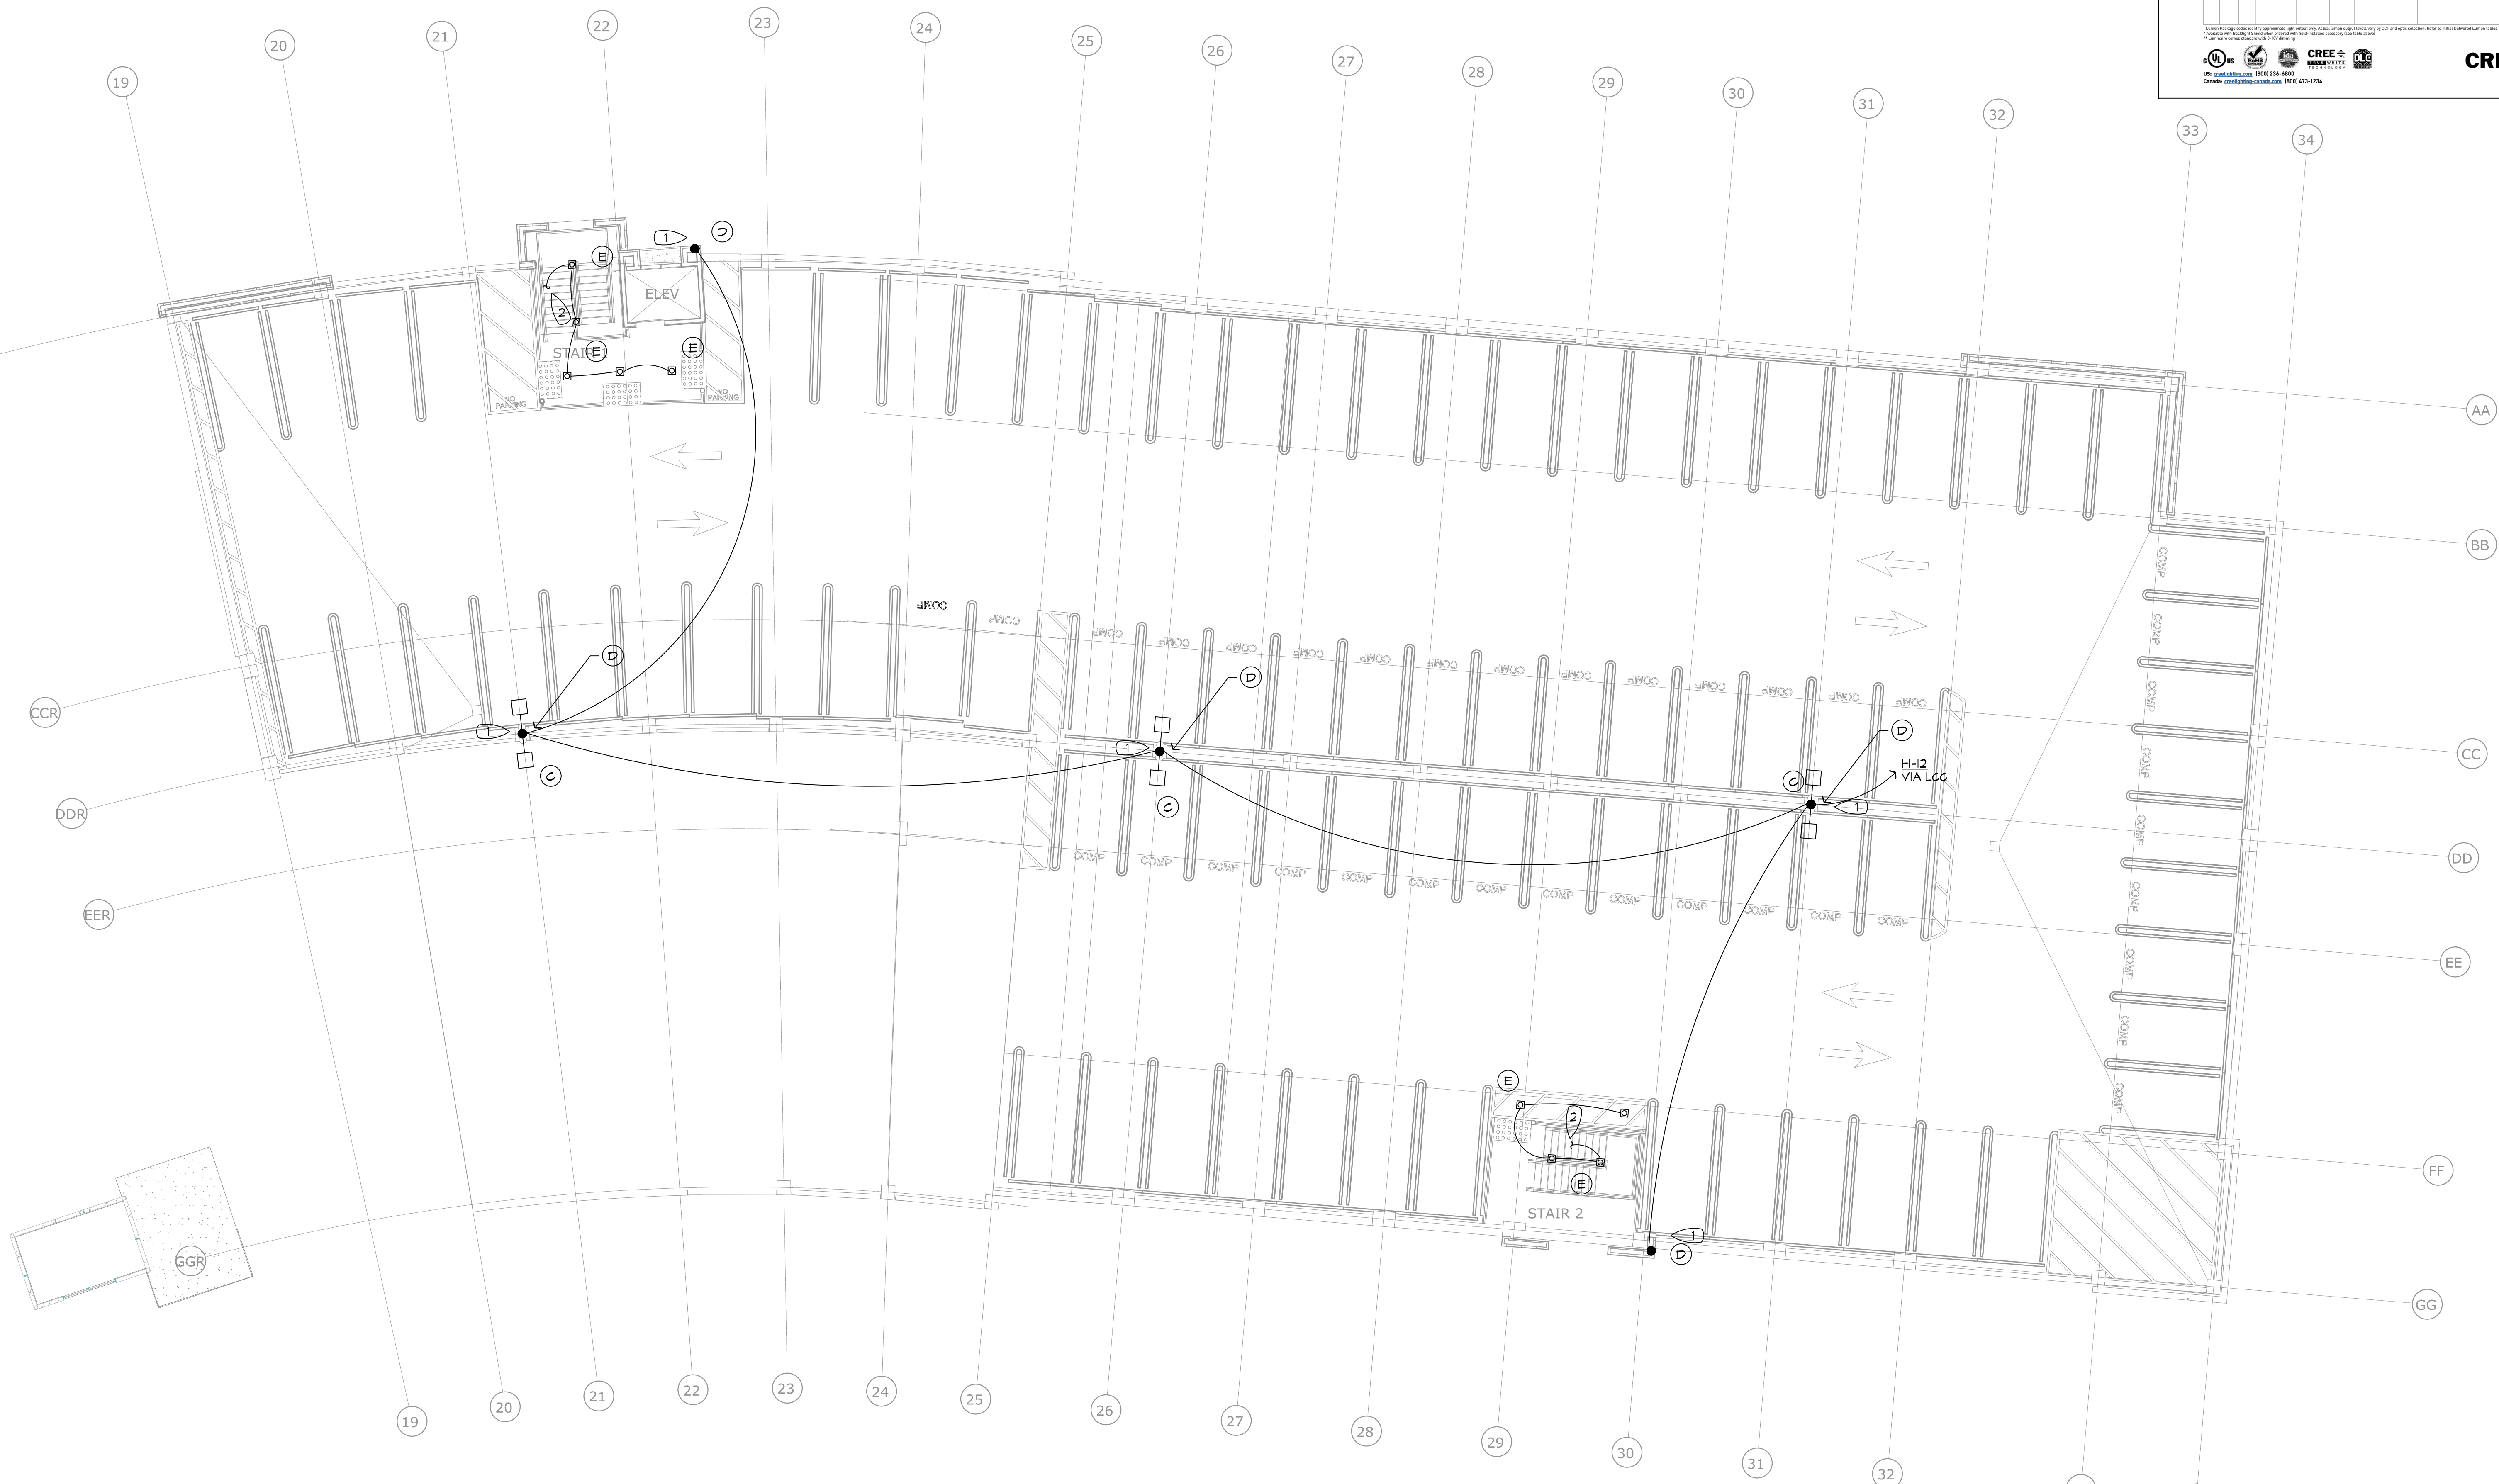[illegible]

LEVEL 06 ELECTRICAL PLAN

Signature

CITY APPROVAL STAMP



City of Roseville Approval

THIS DRAWING IS NOT FINAL OR TO BE
USED FOR CONSTRUCTION UNTIL IT IS
SIGNED BY THE ARCHITECT/ENGINEER

REVISION

BY DATE

SUTTER HEALTH
PARKING GARAGE 12
EXPANSION

12 MEDICAL PLAZA
ROSEVILLE, CA 95661

LEVEL 06 PHOTOMETRICS



LEVEL 06 PHOTOMETRIC PLAN
SCALE: 3/32"=1'-0"