
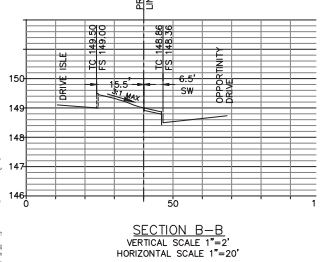
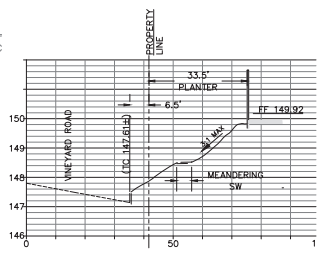


PC EXHIBIT G

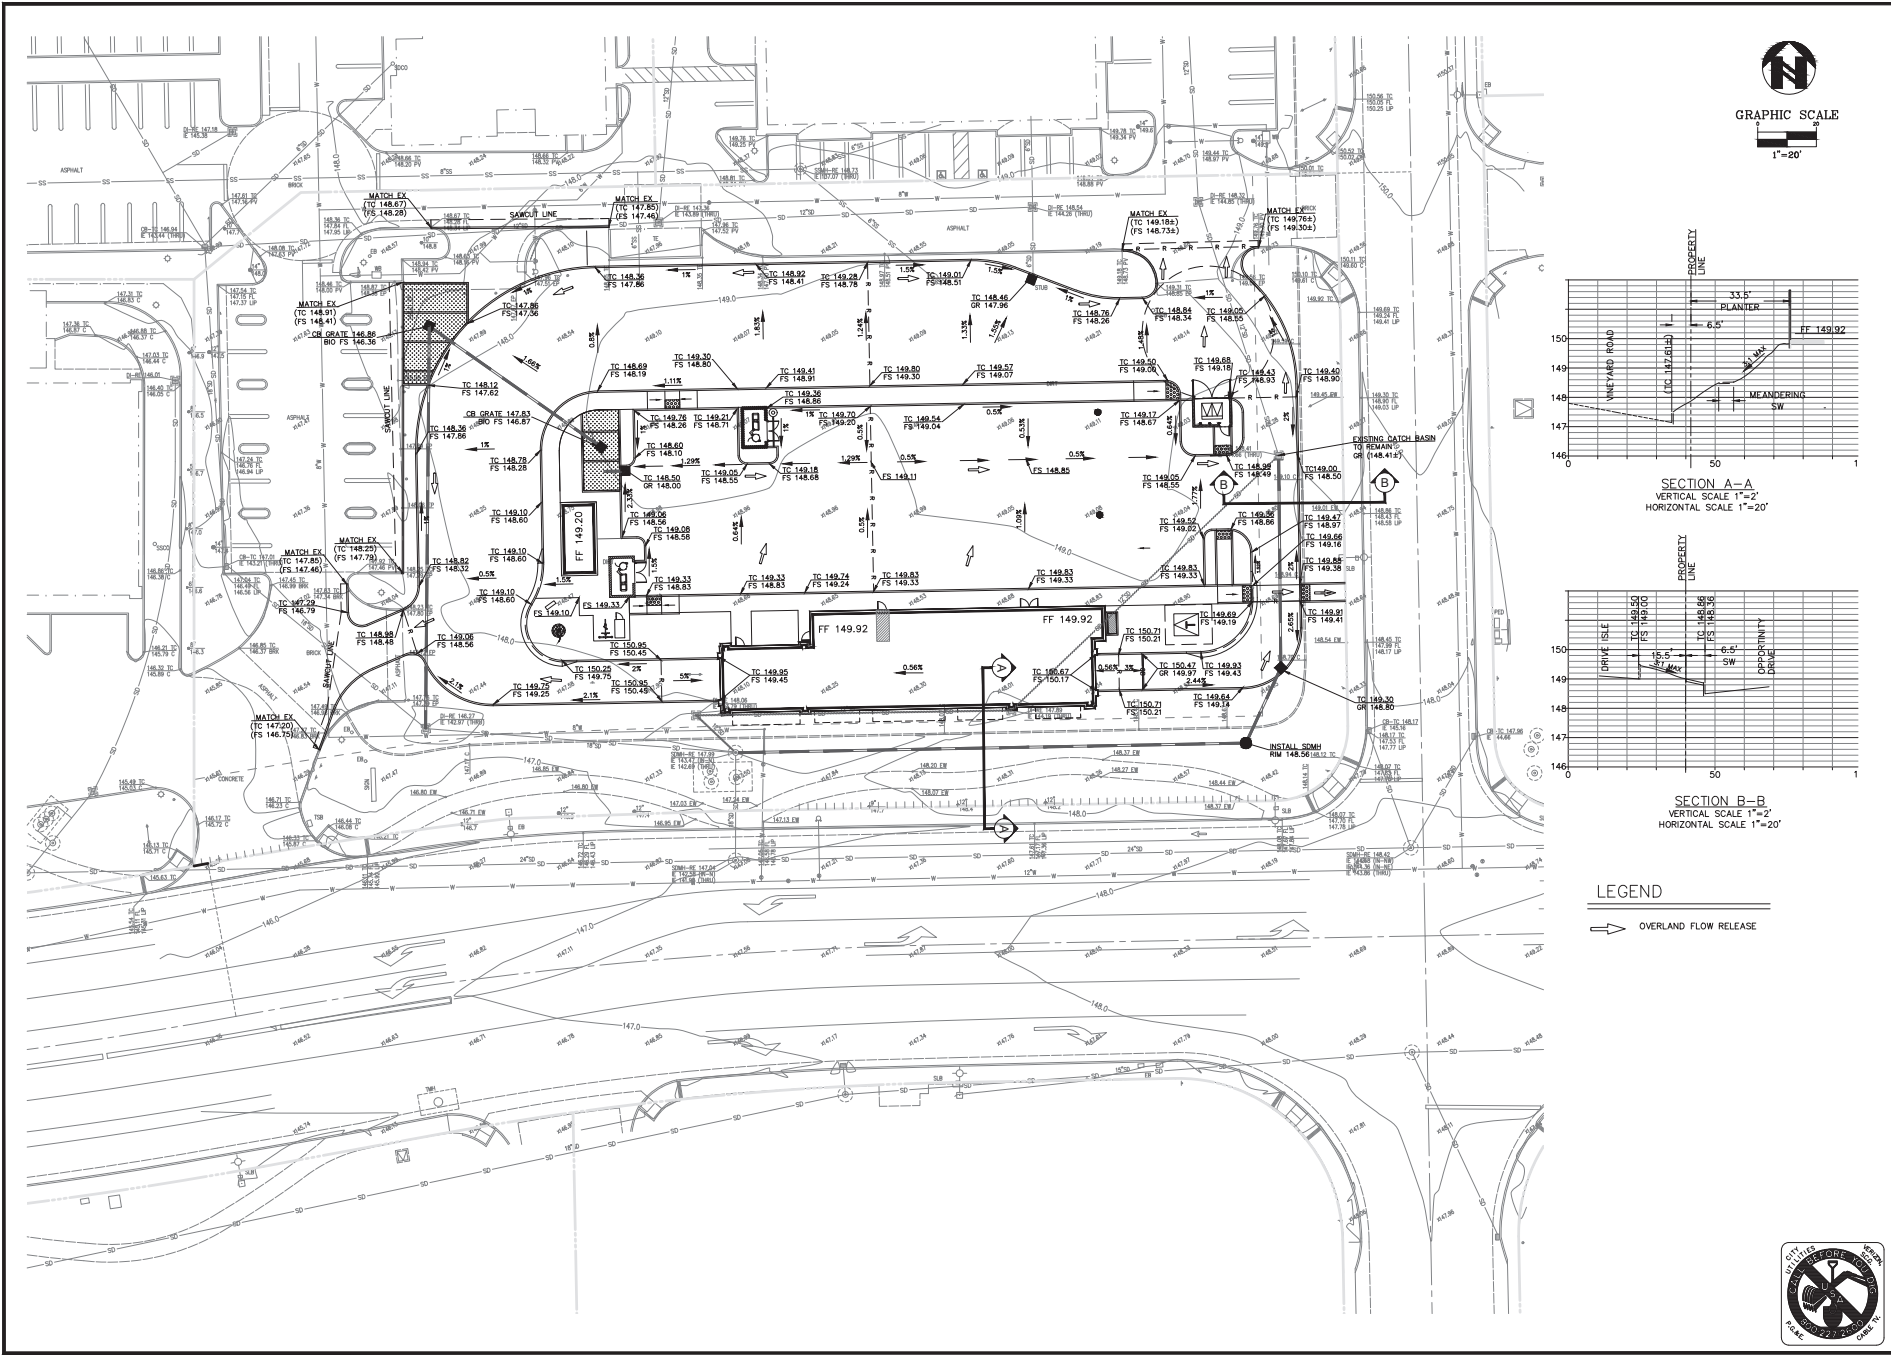

LEGEND
 OVERLAND FLOW RELEASE

DATE:	02-27-23	REV #	BY	DATE	DESCRIPTION
SCALE:	1"=20'				
DESIGNED:					
CHECKED:					
PROJ. MGR.:					
FILE PATH:					

	801 YONACIO VALLEY ROAD WALNUT CREEK, CA 94596 925-943-2777 FAX 925-944-2778
ASSOCIATES, INC.	PLANNING ENGINEERING SURVEYING
CALIFORNIA	PRODUCTION 22-2630 004 26-077 F00THLL AND VINEYARD, ROSEVILLE CA LATEST DATE DIRECTORY 22-11-10\2630GRADE.DWG

SHEET	31
OF	PROJECT
22-2630	GRADING PLAN QUICK QUACK CAR WASH #26-077 1590 VINEYARD ROAD ROSEVILLE

