



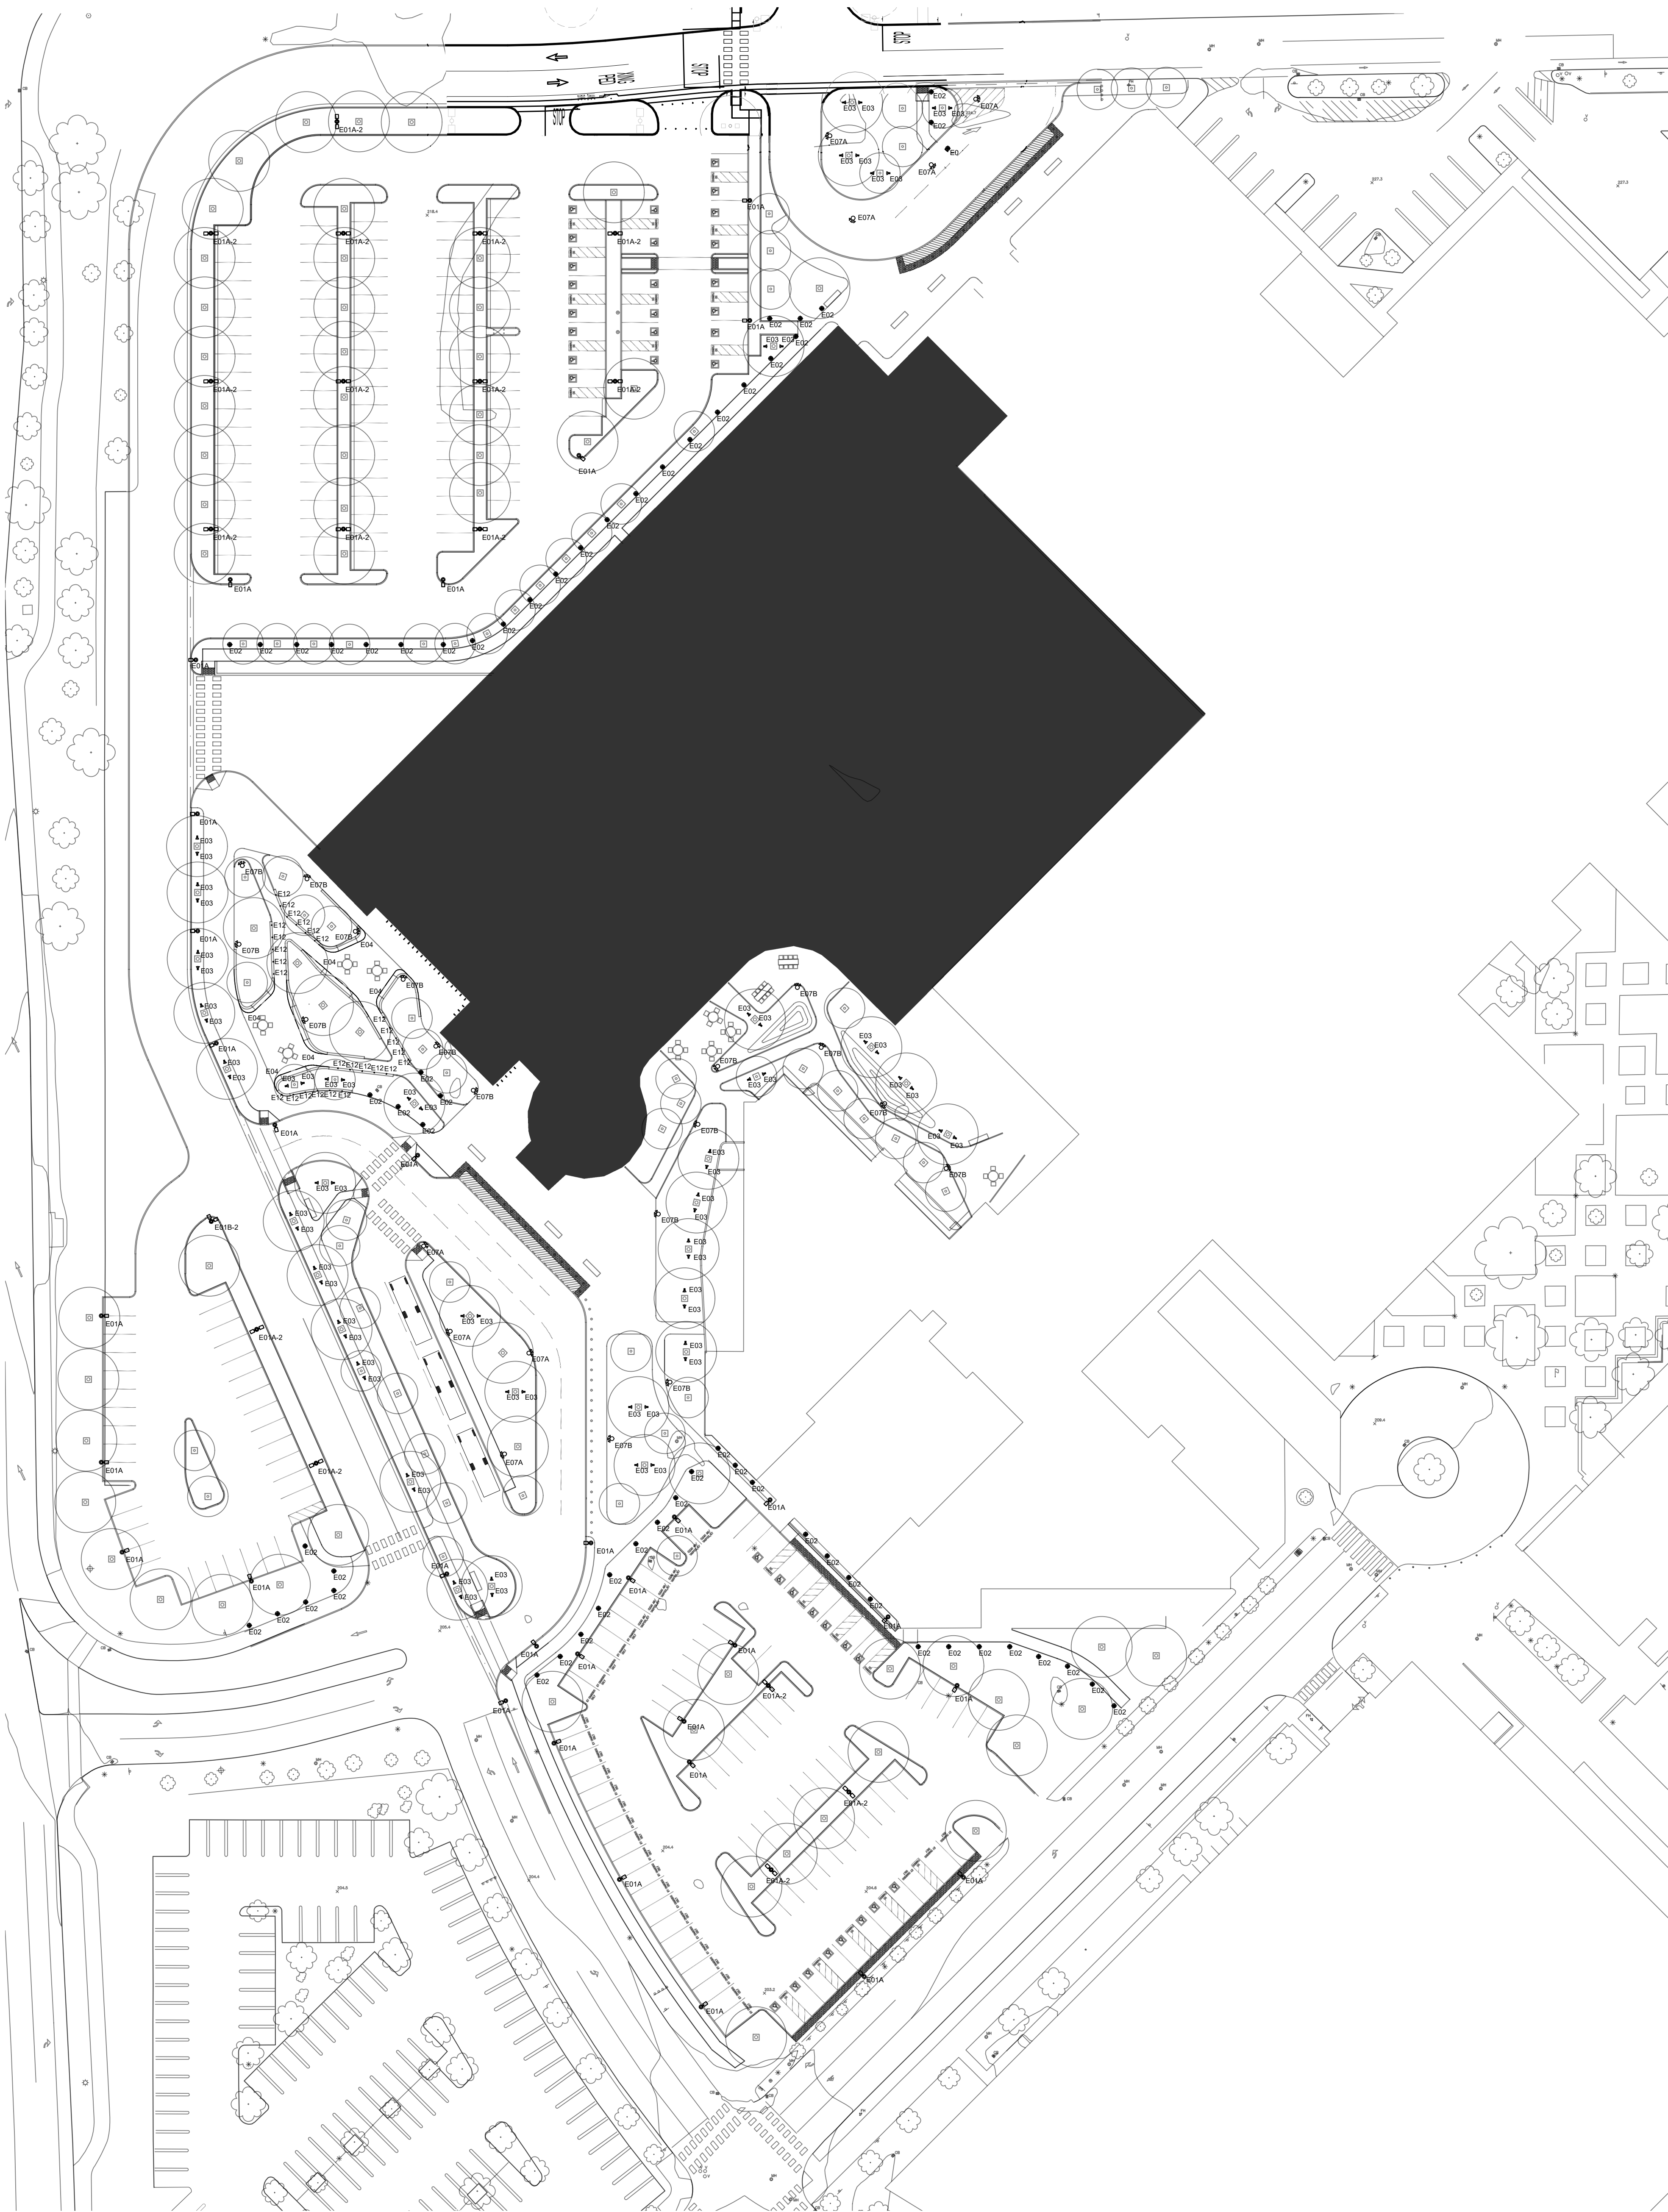

1. West Sector Site Plan

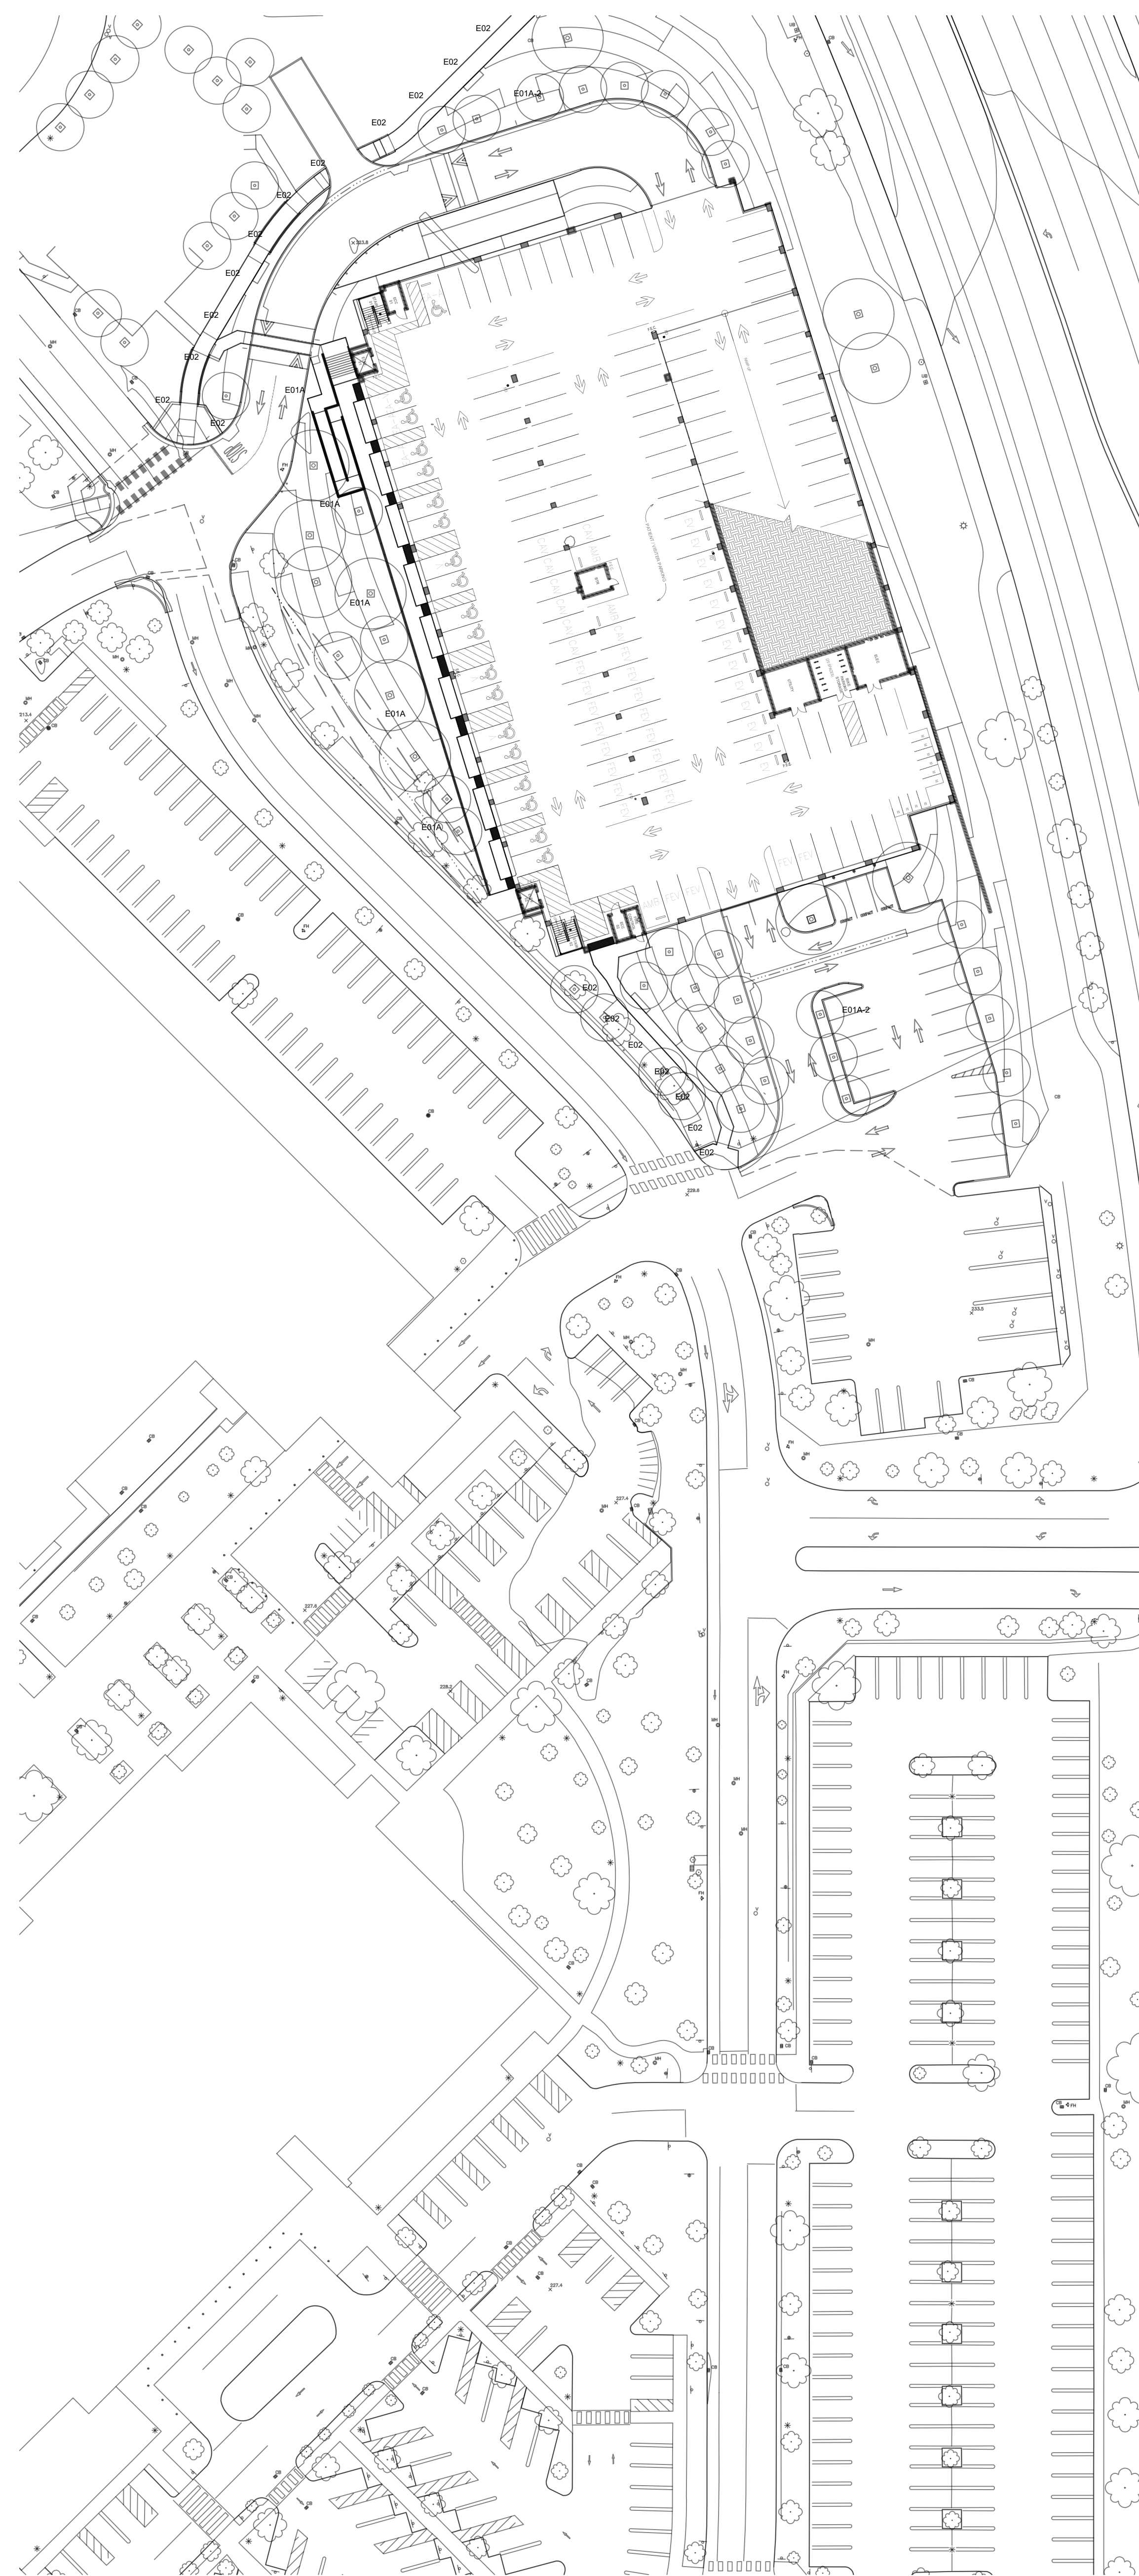

2. East Sector Site Plan

| No. | Revision Description | YYYY-MM-DD |
|-----|----------------------|------------|
| 1   | MPP STAGE 2 RESPONSE | 2022-05-25 |
| 2   | MPP STAGE 2 RESPONSE | 2022-06-30 |
| 3   | MPP STAGE 2 RESPONSE | 2022-08-19 |
| 4   | MPP STAGE 2 RESPONSE | 2022-10-13 |

Agency Approval

Key Plan




Hellmuth, Obata + Kassabaum, Inc.

One Bush Street, Suite 200  
San Francisco, CA 94104 USA  
t +1 415 243 0555 f +1 415 882 7

All reproduction & intellectual property  
rights reserved © 2022  
In Association with  
**BKF ENGINEERS**  
Civil Engineering  
980 9th St, Suite 2300  
Sacramento, CA 95814

Professional Seals

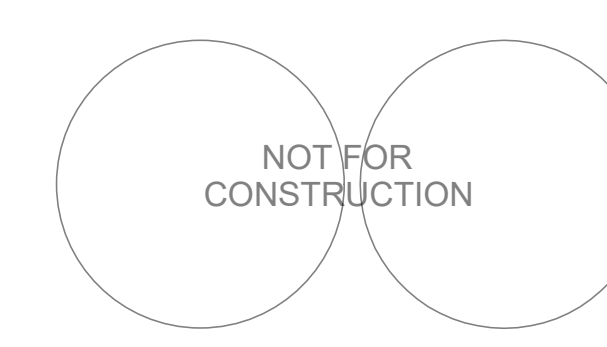

Facility  
**KAISER PERMANENTE  
ROSEVILLE MEDICAL  
CENTER  
ROSEVILLE, CALIFORNIA**

Project  
**INPATIENT BED TOWER  
1600 EUREKA RD  
ROSEVILLE, CA 95661**

Sheet Title  
**SITE LIGHTING PLAN**

Scale:  
**1" = 40'-0"**  
Kaiser Project # CAP015954  
HOK Project # 17.04047.00

Sheet Number  
**LT1.00**

Date:  
**08/19/22**

Original drawing is 42 x 36. Do not scale contents of this d

## SITE LIGHTING FIXTURE SCHEDULE

| TYPE MARK | MANUFACTURER | MODEL NUMBER                      | DESCRIPTION                                                                                                                                                                                    | WATTAGE | WATTAG<br>E UNIT | DELIVERED<br>LUMENS | OUTPUT<br>UNITS | COMMENTS                                 | SOURCE COLOR | COLOR RENDERING | VOLTAGE  | DRIVER TYPE | DRIVER<br>LOCATION | FIXTURE RATING | FIXTURE FINISH |
|-----------|--------------|-----------------------------------|------------------------------------------------------------------------------------------------------------------------------------------------------------------------------------------------|---------|------------------|---------------------|-----------------|------------------------------------------|--------------|-----------------|----------|-------------|--------------------|----------------|----------------|
| E01A      | GARDCO       | P26-48L-400-VVW-G2-3              | POLE TOP LUMINAIRE (TYPE III), LOW GLARE, LOW LIGHT SPILL DOWNLIGHT ONLY, LED POLE LUMINAIRE AT ROADWAYS AND PARKING LOTS, TYPE 3 DISTRIBUTION                                                 | 60      | W                | 7673                | LM              | LOCATION: VARIOUS ROADWAYS/ PARKING LOTS | 2700 K       | 80+ CRI         | 120-277V | 0-10V       | INTEGRAL           | UL WET         | TBD            |
| E01A-2    | GARDCO       | P26-48L-400-VVW-G2-3              | TWIN POLE TOP LUMINAIRE (TYPE III), 180DEG MOUNTING, LOW GLARE, LOW LIGHT SPILL DOWNLIGHT ONLY, LED POLE LUMINAIRE AT ROADWAYS AND PARKING LOTS, TYPE 3 DISTRIBUTION                           | 60      | W/HEAD           | 7673                | LM/HEAD         | LOCATION: VARIOUS ROADWAYS/ PARKING LOTS | 2700 K       | 80+ CRI         | 120-277V | 0-10V       | INTEGRAL           | UL WET         | TBD            |
| E01B-2    | GARDCO       | P26-48L-400-VVW-G2-3              | TWIN POLE TOP LUMINAIRE (TYPE III), 90DEG MOUNTING, LOW GLARE, LOW LIGHT SPILL DOWNLIGHT ONLY, LED POLE LUMINAIRE AT ROADWAYS AND PARKING LOTS, TYPE 3 DISTRIBUTION                            | 60      | W/HEAD           | 7673                | LM/HEAD         | LOCATION: VARIOUS ROADWAYS/ PARKING LOTS | 2700 K       | 80+ CRI         | 120-277V | 0-10V       | INTEGRAL           | UL WET         | TBD            |
| E02       | BEGA         | 84220_K27                         | LED BOLLARD AT EGRESS PATHWAYS WITH FULLY SHIELDED ASYMMETRIC DISTRIBUTION, LOW GLARE, LOW LIGHTSPILL, DOWNLIGHT ONLY                                                                          | 11.5    | W                | 1475                | LM              | LOCATION: VARIOUS PEDESTRIAN PATHS       | 2700 K       | 80+ CRI         | 120-277V | 0-10V       | INTEGRAL           | IP65           | TBD            |
| E03       | ECOSENSE     | F080-1R-MO-27-9-40-K-H-           | ADJUSTABLE LED LUMINAIRE FOR SOFT GLOW ACCENT UPLIGHT ON TREES WITH INTEGRAL DIMMING                                                                                                           | 7.5     | W                | 531                 | LM              | LOCATION: VARIOUS TREES                  | 2700 K       | 80+ CRI         | 120-277V | 0-10V       | INTEGRAL           | UL WET         | TBD            |
| E04       | LUMINI       | KBL-F-V-27K-LENGTH                | FLEXIBLE LED UNDER BENCH LIGHTING                                                                                                                                                              | 3.5     | W/FT             | 178                 | LM/HEAD         | LOCATION: BENCHES                        | 2700 K       | 80+ CRI         | 24V      | 0-10V       | REMOTE             | UL WET         | TBD            |
| E07A      | BEGA         | Fixture: 77653_K27; Pole: 25RFNS1 | 3 HEAD LED ADJUSTABLE PLAZA POLE TOP LUMINAIRE, WITH (3) 51w FIXTURES PER 25FT POLE (+2.5FT POLE BASE) EACH FIXTURE FULLY AIMABLE/ADJUSTABLE WITH SHIELDING SNOOT, LOW GLARE, LOW LIGHT SPILL  | 153     | W/HEAD           | 4215                | LM/HEAD         | LOCATION: DROP OFF AREAS                 | 2700 K       | 80+ CRI         | 120-277V | 0-10V       | INTEGRAL           | IP65           | TBD            |
| E07B      | BEGA         | Fixture: 77653_K27; Pole: 14RFNS1 | 3 HEAD LED ADJUSTABLE PLAZA POLE TOP LUMINAIRE, WITH (3) 51w FIXTURES PER 14FT POLE (+2.5FT POLE BASE). EACH FIXTURE FULLY AIMABLE/ADJUSTABLE WITH SHIELDING SNOOT, LOW GLARE, LOW LIGHT SPILL | 153     | W/HEAD           | 4215                | LM/HEAD         | LOCATION: VARIOUS PEDESTRIAN PATHS       | 2700 K       | 80+ CRI         | 120-277V | 0-10V       | INTEGRAL           | IP65           | TBD            |
| E12       | BEGA         | 33055_K27_BLK                     | WALL RECESSED STEPLIGHT                                                                                                                                                                        | 8.4     | W                | 480                 | LM              | LOCATION: VARIOUS PEDESTRIAN PATHS       | 2700 K       | 80+ CRI         | 120-277V | 0-10V       | INTEGRAL           | IP65           | TBD            |



## CAISER PERMANENTE

KAISER PERMANENTE  
KAISER FOUNDATION  
HEALTH PLAN INC

NATIONAL FACILITIES SERVICES  
POST OFFICE BOX 12916  
OAKLAND, CA 94604

| No. | Revision Description   | YYYY-MM-DD |
|-----|------------------------|------------|
|     | MPP STAGE 2            | 2022-05-25 |
|     | MPP STAGE 2 RESPONSE   | 2022-06-30 |
| 2   | MPP STAGE 2 RESPONSE 2 | 2022-08-19 |

Agency Approval

## Plan



Ilmuth, Obata + Kassabaum, Inc.


1415 Bush Street, Suite 200  
San Francisco, CA 94104 USA  
t +1 415 243 0555 f +1 415 882 7

reproduction & intellectual property  
is reserved © 2021

association with

**F ENGINEERS**  
Engineering  
9th St, Suite 2300  
Sacramento, CA 95814

### Professional Seals

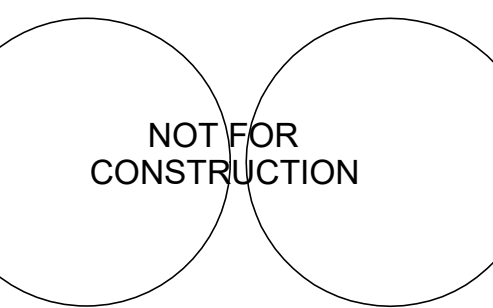

USER PERMANENTE  
SEVILLE MEDICAL  
CENTER  
SEVILLE, CALIFORNIA

PATIENT BED TOWER  
100 EUREKA RD  
SEVILLE, CA 95661

1 Title

## TEXTURE SCHEDULE

HOK Project # 17.04047.00

Client Name: \_\_\_\_\_

9/22

T1.01

drawing is 42 x 30. Do not scale contents of this drawing.